

Drawing List - Jhandutta Block and Swarghat Block , Bilaspur District

S.NO.	DRAWING. NO.	SOFT COPY FILE NAME	TITLE	SIZE	ISSUE
1	TCE.12503A-CV-3005-LM-30061	12503A-CV-30061-Rev-P0	Topographical Survey for Balh Sihna Cluster	A3	P0
2	TCE.12503A-CV-3005-LM-30062	12503A-CV-30062-Rev-P0	Topographical Survey for Bassi Cluster	A3	P0
3	TCE.12503A-CV-3005-LM-30063	12503A-CV-30063-Rev-P0	Topographical Survey for Dulhet-3 Cluster	A3	P0
4	TCE.12503A-CV-3005-LM-30064	12503A-CV-30064-Rev-P0	Topographical Survey for Fagog Cluster	A3	P0
5	TCE.12503A-CV-3005-LM-30065	12503A-CV-30065-Rev-P0	Topographical Survey for Fagog Bhanjoli Cluster	A3	P0
6	TCE.12503A-CV-3005-LM-30066	12503A-CV-30066-Rev-P0	Topographical Survey for Ghattewal Cluster	A3	P0
7	TCE.12503A-CV-3005-LM-30067	12503A-CV-30067-Rev-P0	Topographical Survey for Jhandu Cluster	A3	P0
8	TCE.12503A-CV-3005-LM-30068	12503A-CV-30068-Rev-P0	Topographical Survey for Kosariyan Cluster	A3	P0
9	TCE.12503A-CV-3005-LM-30069	12503A-CV-30069-Rev-P0	Topographical Survey for Tikri Kotlu Cluster	A3	P0
10	TCE.12503A-CV-3005-LM-30070	12503A-CV-30070-Rev-P0	Topographical Survey for Lehar Cluster	A3	P0
11	TCE.12503A-CV-3005-LM-30071	12503A-CV-30071-Rev-P0	Topographical Survey for Tihri Cluster	A3	P0
12	TCE.12503A-CV-3005-LM-30661	12503A-CV-30661-Rev-P0	Key Plan of Balh Sihna Cluster	A3	P0
13	TCE.12503A-CV-3005-LM-30662	12503A-CV-30662-Rev-P0	Key Plan of Fagog & Fagog Bhanjoli Cluster	A3	P0
14	TCE.12503A-CV-3005-LM-30663	12503A-CV-30663-Rev-P0	Key Plan of Jhandu Cluster	A3	P0
15	TCE.12503A-CV-3005-LM-30664	12503A-CV-30664-Rev-P0	Key Plan of Kosariyan Cluster	A3	P0
16	TCE.12503A-CV-3005-LM-30665	12503A-CV-30665-Rev-P0	Key Plan of Tikri Kotlu Cluster	A3	P0
17	TCE.12503A-CV-3005-LM-30666	12503A-CV-30666-Rev-P0	Key Plan of Lehar Cluster	A3	P0
18	TCE.12503A-CV-3005-LM-30667	12503A-CV-30667-Rev-P0	Key Plan of Tihri Cluster	A3	P0
19	TCE.12503A-CV-3005-LM-30668	12503A-CV-30668-Rev-P0	Key Plan of Bassi, Ghattewal and Dulhet-3	A3	P0
20	TCE.12503A-CV-3082-FD-30077	12503A-CV-30077-Rev-P1	Flow Diagram for Proposed LIS Fagog and Fagog Banjholi	A3	P1
21	TCE.12503A-CV-3082-FD-30078	12503A-CV-30078-Rev-P1	Flow Diagram for Proposed LIS Jhandu	A3	P1
22	TCE.12503A-CV-3082-FD-30079	12503A-CV-30079-Rev-P1	Flow Diagram for Proposed LIS Kosariyan-1	A3	P1
23	TCE.12503A-CV-3082-FD-30080	12503A-CV-30080-Rev-P1	Flow Diagram for Proposed LIS Tikri Kotlu	A3	P1
24	TCE.12503A-CV-3082-FD-30081	12503A-CV-30081-Rev-P1	Flow Diagram for Proposed LIS Lehar	A3	P1
25	TCE.12503A-CV-3082-FD-30082	12503A-CV-30082-Rev-P1	Flow Diagram for Proposed LIS Tihri	A3	P1
26	TCE.12503A-CV-3082-FD-30083	12503A-CV-30083-Rev-P1	Flow Diagram for Existing LIS Changer	A3	P1
27	TCE.12503A-CV-3082-FD-30084	12503A-CV-30084-Rev-P1	Flow Diagram for Proposed LIS Balh Sihna	A3	P1
28	TCE.12503A-CV-3082-WS-30684	12503A-CV-30684-Rev-P1	Proposed L-Section - LIS Tihri (Sheet 1 of 2)	A3	P1
29	TCE.12503A-CV-3082-WS-30685	12503A-CV-30685-Rev-P1	Proposed L-Section - LIS Tihri (Sheet 2 of 2)	A3	P1
30	TCE.12503A-CV-3082-WS-30686	12503A-CV-30686-Rev-P1	Proposed L-Section - LIS Fagog Banjoli (Sheet 1 of 3)	A3	P1
31	TCE.12503A-CV-3082-WS-30687	12503A-CV-30687-Rev-P1	Proposed L-Section - LIS Fagog Banjoli (Sheet 2 of 3)	A3	P1
32	TCE.12503A-CV-3082-WS-30688	12503A-CV-30688-Rev-P1	Proposed L-Section - LIS Fagog Banjoli (Sheet 3 of 3)	A3	P1
33	TCE.12503A-CV-3082-WS-30689	12503A-CV-30689-Rev-P1	Proposed L-Section - LIS Jhandu (Sheet 1 of 2)	A3	P1
34	TCE.12503A-CV-3082-WS-30690	12503A-CV-30690-Rev-P1	Proposed L-Section - LIS Jhandu (Sheet 2 of 2)	A3	P1
35	TCE.12503A-CV-3082-WS-30691	12503A-CV-30691-Rev-P1	Proposed L-Section - LIS Tikri Kothlu (Sheet 1 of 2)	A3	P1
36	TCE.12503A-CV-3082-WS-30692	12503A-CV-30692-Rev-P1	Proposed L-Section - LIS Tikri Kothlu (Sheet 2 of 2)	A3	P1
37	TCE.12503A-CV-3082-WS-30693	12503A-CV-30693-Rev-P1	Proposed L-Section - LIS Lehar (Sheet 1 of 3)	A3	P1
38	TCE.12503A-CV-3082-WS-30694	12503A-CV-30694-Rev-P1	Proposed L-Section - LIS Lehar (Sheet 2 of 3)	A3	P1
39	TCE.12503A-CV-3082-WS-30695	12503A-CV-30695-Rev-P1	Proposed L-Section - LIS Lehar (Sheet 3 of 3)	A3	P1
40	TCE.12503A-CV-3082-WS-30696	12503A-CV-30696-Rev-P1	Proposed L-Section - LIS Kosariyan (Sheet 1 of 3)	A3	P1
41	TCE.12503A-CV-3082-WS-30697	12503A-CV-30697-Rev-P1	Proposed L-Section - LIS Kosariyan (Sheet 2 of 3)	A3	P1
42	TCE.12503A-CV-3082-WS-30698	12503A-CV-30698-Rev-P1	Proposed L-Section - LIS Kosariyan (Sheet 3 of 3)	A3	P1
43	TCE.12503A-CV-3082-WS-30699	12503A-CV-30699-Rev-P1	Proposed L-Section - LIS Balh Sihna (Sheet 1 of 3)	A3	P1
44	TCE.12503A-CV-3082-WS-30700	12503A-CV-30700-Rev-P1	Proposed L-Section - LIS Balh Sihna (Sheet 2 of 3)	A3	P1
45	TCE.12503A-CV-3082-WS-30701	12503A-CV-30701-Rev-P1	Proposed L-Section - LIS Balh Sihna (Sheet 3 of 3)	A3	P1


Drawing List - Jhandutta Block and Swarghat Block , Bilaspur District

S.NO.	DRAWING. NO.	SOFT COPY FILE NAME	TITLE	SIZE	ISSUE
46	TCE.12503A-CV-3082-WS-30702	12503A-CV-30702-Rev-P1	Proposed L-Section - LIS Changer (Sheet 1 of 6)	A3	P1
47	TCE.12503A-CV-3082-WS-30703	12503A-CV-30703-Rev-P1	Proposed L-Section - LIS Changer (Sheet 2 of 6)	A3	P1
48	TCE.12503A-CV-3082-WS-30704	12503A-CV-30704-Rev-P1	Proposed L-Section - LIS Changer (Sheet 3 of 6)	A3	P1
49	TCE.12503A-CV-3082-WS-30705	12503A-CV-30705-Rev-P1	Proposed L-Section - LIS Changer (Sheet 4 of 6)	A3	P1
50	TCE.12503A-CV-3082-WS-30706	12503A-CV-30706-Rev-P1	Proposed L-Section - LIS Changer (Sheet 5 of 6)	A3	P1
51	TCE.12503A-CV-3082-WS-30707	12503A-CV-30707-Rev-P1	Proposed L-Section - LIS Changer (Sheet 6 of 6)	A3	P1
52	TCE.12503A-CV -3082-WS-30715	12503A-CV-30715-Rev-P1	Network drawing for LIS Balh Sihna	A3	P1
53	TCE.12503A-CV -3082-WS-30716	12503A-CV-30716-Rev-P1	Network drawing for LIS Fagog & Fagog Banjhohli	A3	P1
54	TCE.12503A-CV -3082-WS-30717	12503A-CV-30717-Rev-P1	Network drawing for LIS Jhandu	A3	P1
55	TCE.12503A-CV -3082-WS-30718	12503A-CV-30718-Rev-P1	Network drawing for LIS Kosarian	A3	P1
56	TCE.12503A-CV -3082-WS-30719	12503A-CV-30719-Rev-P1	Network drawing for LIS Tikri Kotlu	A3	P1
57	TCE.12503A-CV -3082-WS-30720	12503A-CV 30720-Rev-P1	Network drawing for LIS Lehar	A3	P1
58	TCE.12503A-CV -3082-WS-30721	12503A-CV-30721-Rev-P1	Network drawing for LIS Tihri	A3	P1
59	TCE.12503A-CV -3082-WS-30722	12503A-CV-30722-Rev-P1	Network drawing for LIS Changer (Bassi, Dulhet-3 & Ghattewal)	A3	P1
60	TCE.12503A-CV-3082-WS-30581	12503A-CV-30581-Rev-P0	Typical Sluice Valve Chamber Details	A3	P0
61	TCE.12503A-CV-3082-WS-30582	12503A-CV-30582-Rev-P0	Typical Details for Thrust Block	A3	P0
62	TCE.12503A-CV-3082-RC-30583	12503A-CV-30583-Rev-P0	Typical Details for Saddle Support	A3	P0
63	TCE.12503A-CV-3082-GA-30584	12503A-CV-30584-Rev-P0	Typical GLSR Details (100000, 150000, 200000, 250000 Litre Capacity)	A3	P0
64	TCE.12503A-CV-3082-WS-30585	12503A-CV-30585-Rev-P0	Typical Details for Scour Valve and Air Valve Chamber	A3	P0
65	TCE.12503A-CV-3082-GA-30586	12503A-CV-30586-Rev-P0	Typical Details for Pump House and Sump	A3	P0
66	TCE.12503A-CV-3082-GA-30587	12503A-CV-30587-Rev-P1	General Arrangement for Intake Well	A3	P1
67	TCE.12503A-CV-3082-WS-30588	12503A-CV-30588-Rev-P0	General Arrangement for Intake Well	A3	P0
68	TCE.12503A-CV-3082-GA-30589	12503A-CV-30589-Rev-P0	General Arrangement for Check Dam	A3	P0
69	TCE.12503A-CV-3082-GA-30590	12503A-CV-30590-Rev-P0	Typical Detail for Desilting Tank	A3	P0
70	TCE.12503A-CV-3082-GA-30591	12503A-CV-30591-Rev-P0	Typical details for ELSR	A3	P0
71	TCE.12503A-CV-3082-GA-30592	12503A-CV-30592-Rev-P0	Typical details of Percolation Well	A3	P0
72	TCE.12503A-EL-4002-AU-40001	12503A-EL-40001-Rev-P0	Typical SLD for LIS Pumping Station with 1W+1S units & LT Metering	A3	P0
73	TCE.12503A-EL-4002-AU-40002	12503A-EL-40002-Rev-P0	Typical SLD for LIS Pumping Station with 1W+1S units & HT Metering	A3	P0
74	TCE.12503A-EL-4002-AU-40003	12503A-EL-40003-Rev-P0	Typical SLD for LIS Pumping Station with 2W+1S units & HT Metering	A3	P0
75	TCE.12503A-EL-4002-AU-40004	12503A-EL-40004-Rev-P0	Typical SLD for LIS Pumping Station having LT/ HT Motor Loads - General Notes & Legends	A3	P0

**ABBREVIATIONS**

Flow Diagram Drawings		Typical Standard drawings		L-Section drawings		Topographical Survey Drawings	
Q	Discharge (Flow)	HT	High Tension	J	Pipe Junction	GI	Galvanised Iron
H	Pump head	LT	Low Tension	CT	Collection Tank	TBM	Temporary Bench Mark
GI	Galvanised Iron	ELSR	Elevated service reservoir	MT	Modular Tank	GL	Ground Level
Lat.	Latitude	c/c	centre to centre	MDT	Main Distribution Tank	PH	Pump House
Long	Longitude	M20/ M15	Grade of concrete	MSERW	Mild steel Electric resistance welded pipe	WT	Water Tank
RL	Reduced Level	GLSR	Ground Level service reservoir	GI	Galvanised Iron	N	Northing
RD	Reduced Distance	Typ	Typical	Pmp	Pump	E	Easting
MT	Modular Tank	SLD	Single Line Diagram				
MDT	Main Distribution Tank						
Ha	Hectare						
MSERW	Mild steel Electric resistance welded pipe						



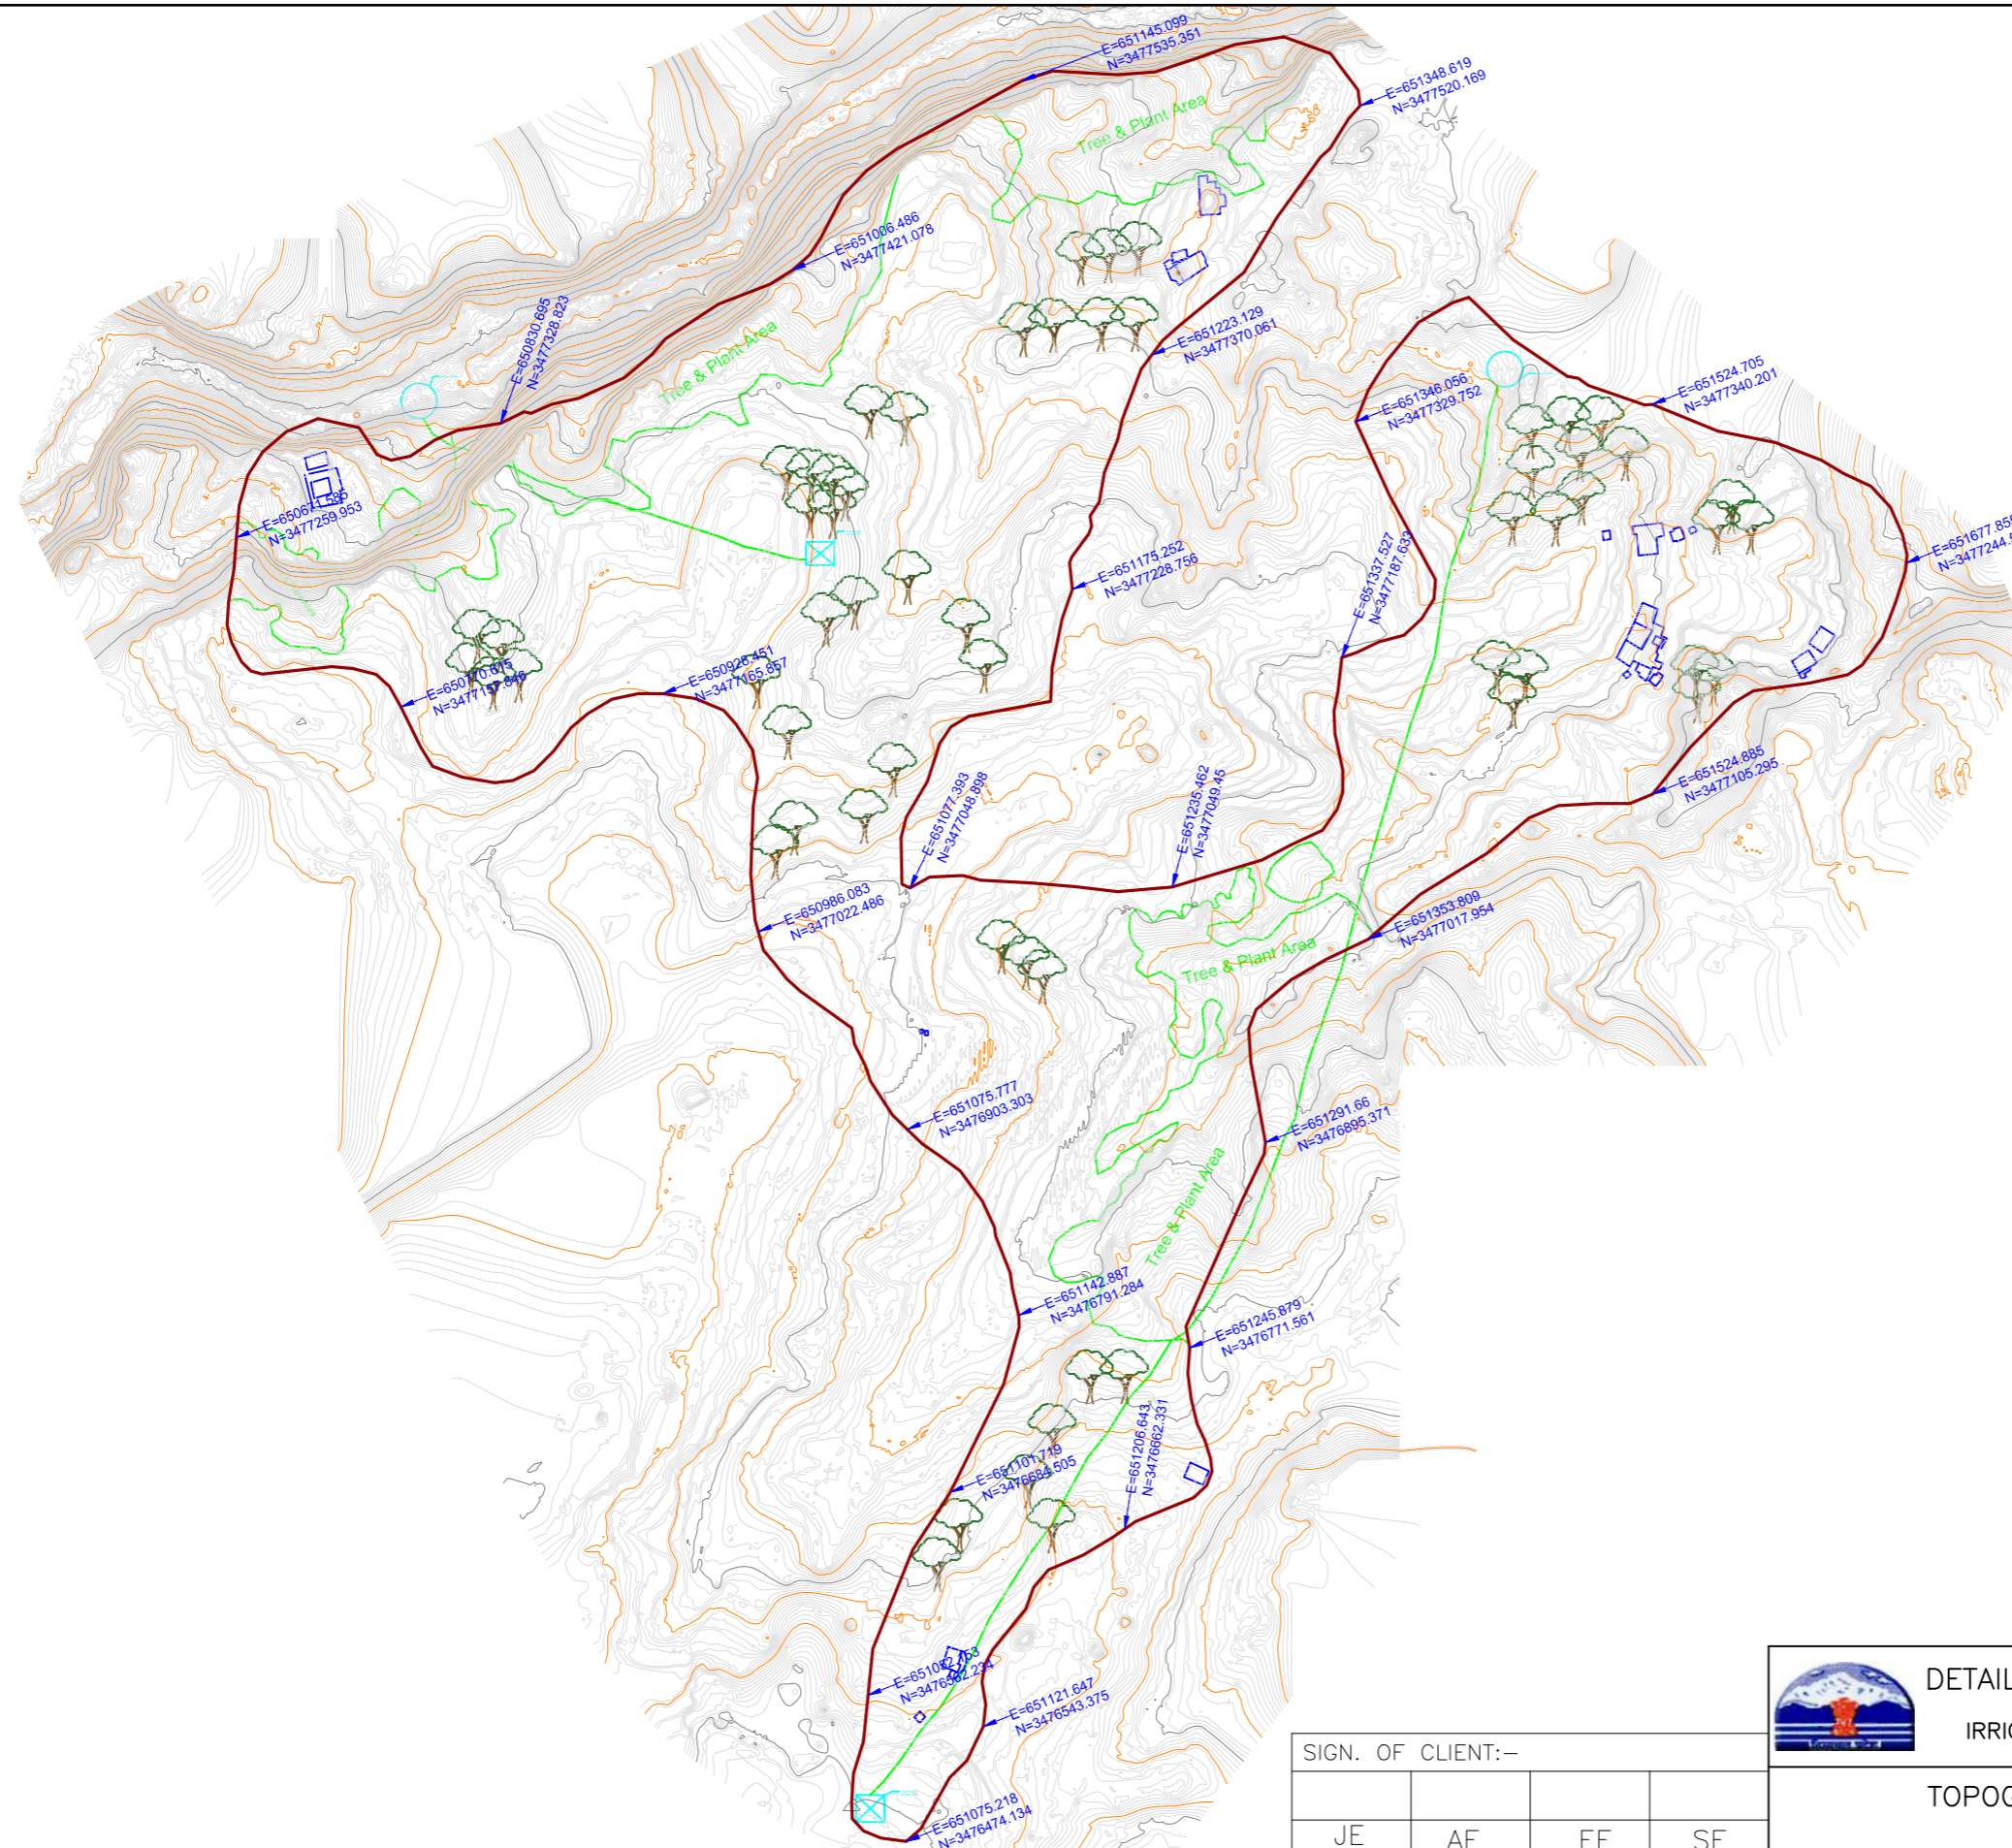

- LEGEND:-
- 1. BOUNDARY WALL
  - 2. BUILDING
  - 3. HDPE WATER OUTLET PIPE
  - 4. WATER INLET PIPE
  - 5. OVERFLOW WATER PIPE
  - 6. TREE
  - 7. FLD
  - 8. BENCH MARK / TBM. TBM  
580.000
  - 9. WATER FLOW



DETAILED DESIGN CONSULTANCY, HP-SHIVA (PACKAGE CS09)  
IRRIGATION, HORTICULTURE, ORCHARDS AND VALUE CHAIN DEVELOPMENT

TOPOGRAPHICAL SURVEY FOR BALH SIHNA CLUSTER  
JHANDUTTA BLOCK, BILASPUR DISTRICT

SIGN. OF CLIENT:-

JE	AE	EE	SE
----	----	----	----

PURPOSE: FOR TENDER ONLY  
DO NOT SCALE

Proprietary Notice and Version Control: This document contains confidential information for use only by the Client. It is provided for the sole purpose of permitting the recipient to evaluate the information submitted hereon, in consideration of receipt of this document, unless agreed to in the Contract; the recipient agrees to maintain such information in confidence and to not reproduce or otherwise disclose this information to any person outside the recipient's organization; except that there is no obligation to maintain the confidentiality of any information which was known to the recipient prior to receipt of such information from Tata Consulting Engineers Limited, or becomes publicly known through no fault of recipient, or Tata Consulting Engineers Limited, or is received without obligation of confidentiality from a third party owing no obligation of confidentiality to Tata Consulting Engineers Limited. All information given under this version over rides all and any kind of offers, assumptions, deliverables and contracts submitted verbally (and subsequently communicated in writing) or in writing or otherwise given under any and all previous version/s.

## TATA CONSULTING ENGINEERS LIMITED

MUMBAI

SCALE : NTS	DWG NO. TCE.12503A-CV-3005-LM-30061	ISSUE PO
-------------	-------------------------------------	----------

FILE NAME: 12503A-CV-30061-Rev-P0 DC & DISC: DEL-CV



 
SIGN.												
	INITIALS											
	REVISIONS											
PO	SIGN.											
	GKJ	ES	DVB					MK	DK	08-04-2022		
	REVISIONS											
ISSUE	DRN	DSN	CHD	CV	EL	IC	ME			PE/PM	APPD	DATE
	CLEARED											

'P' (PRELIMINARY) ISSUES ARE NOT TO BE USED FOR CONSTRUCTION / FABRICATION BUT ARE ISSUED FOR LIMITED PURPOSES ONLY AS INDICATED IN THE SMALL BLOCK ABOVE THIS BLOCK.

CONSTRUCTION / FABRICATION WORK IS PERMITTED ON 'R' (RELEASED) ISSUES ONLY.

INFORMATION CONTAINED WITHIN 'HOLD' IS NOT RELEASED FOR CONSTRUCTION / FABRICATION. FIELD MUST GET DESIGN OFFICE TO CLEAR 'HOLD'S' IN TIME BEFORE PROCEEDING WITH ANY CONSTRUCTION/ FABRICATION WORK RELATED TO 'HOLD'S'.



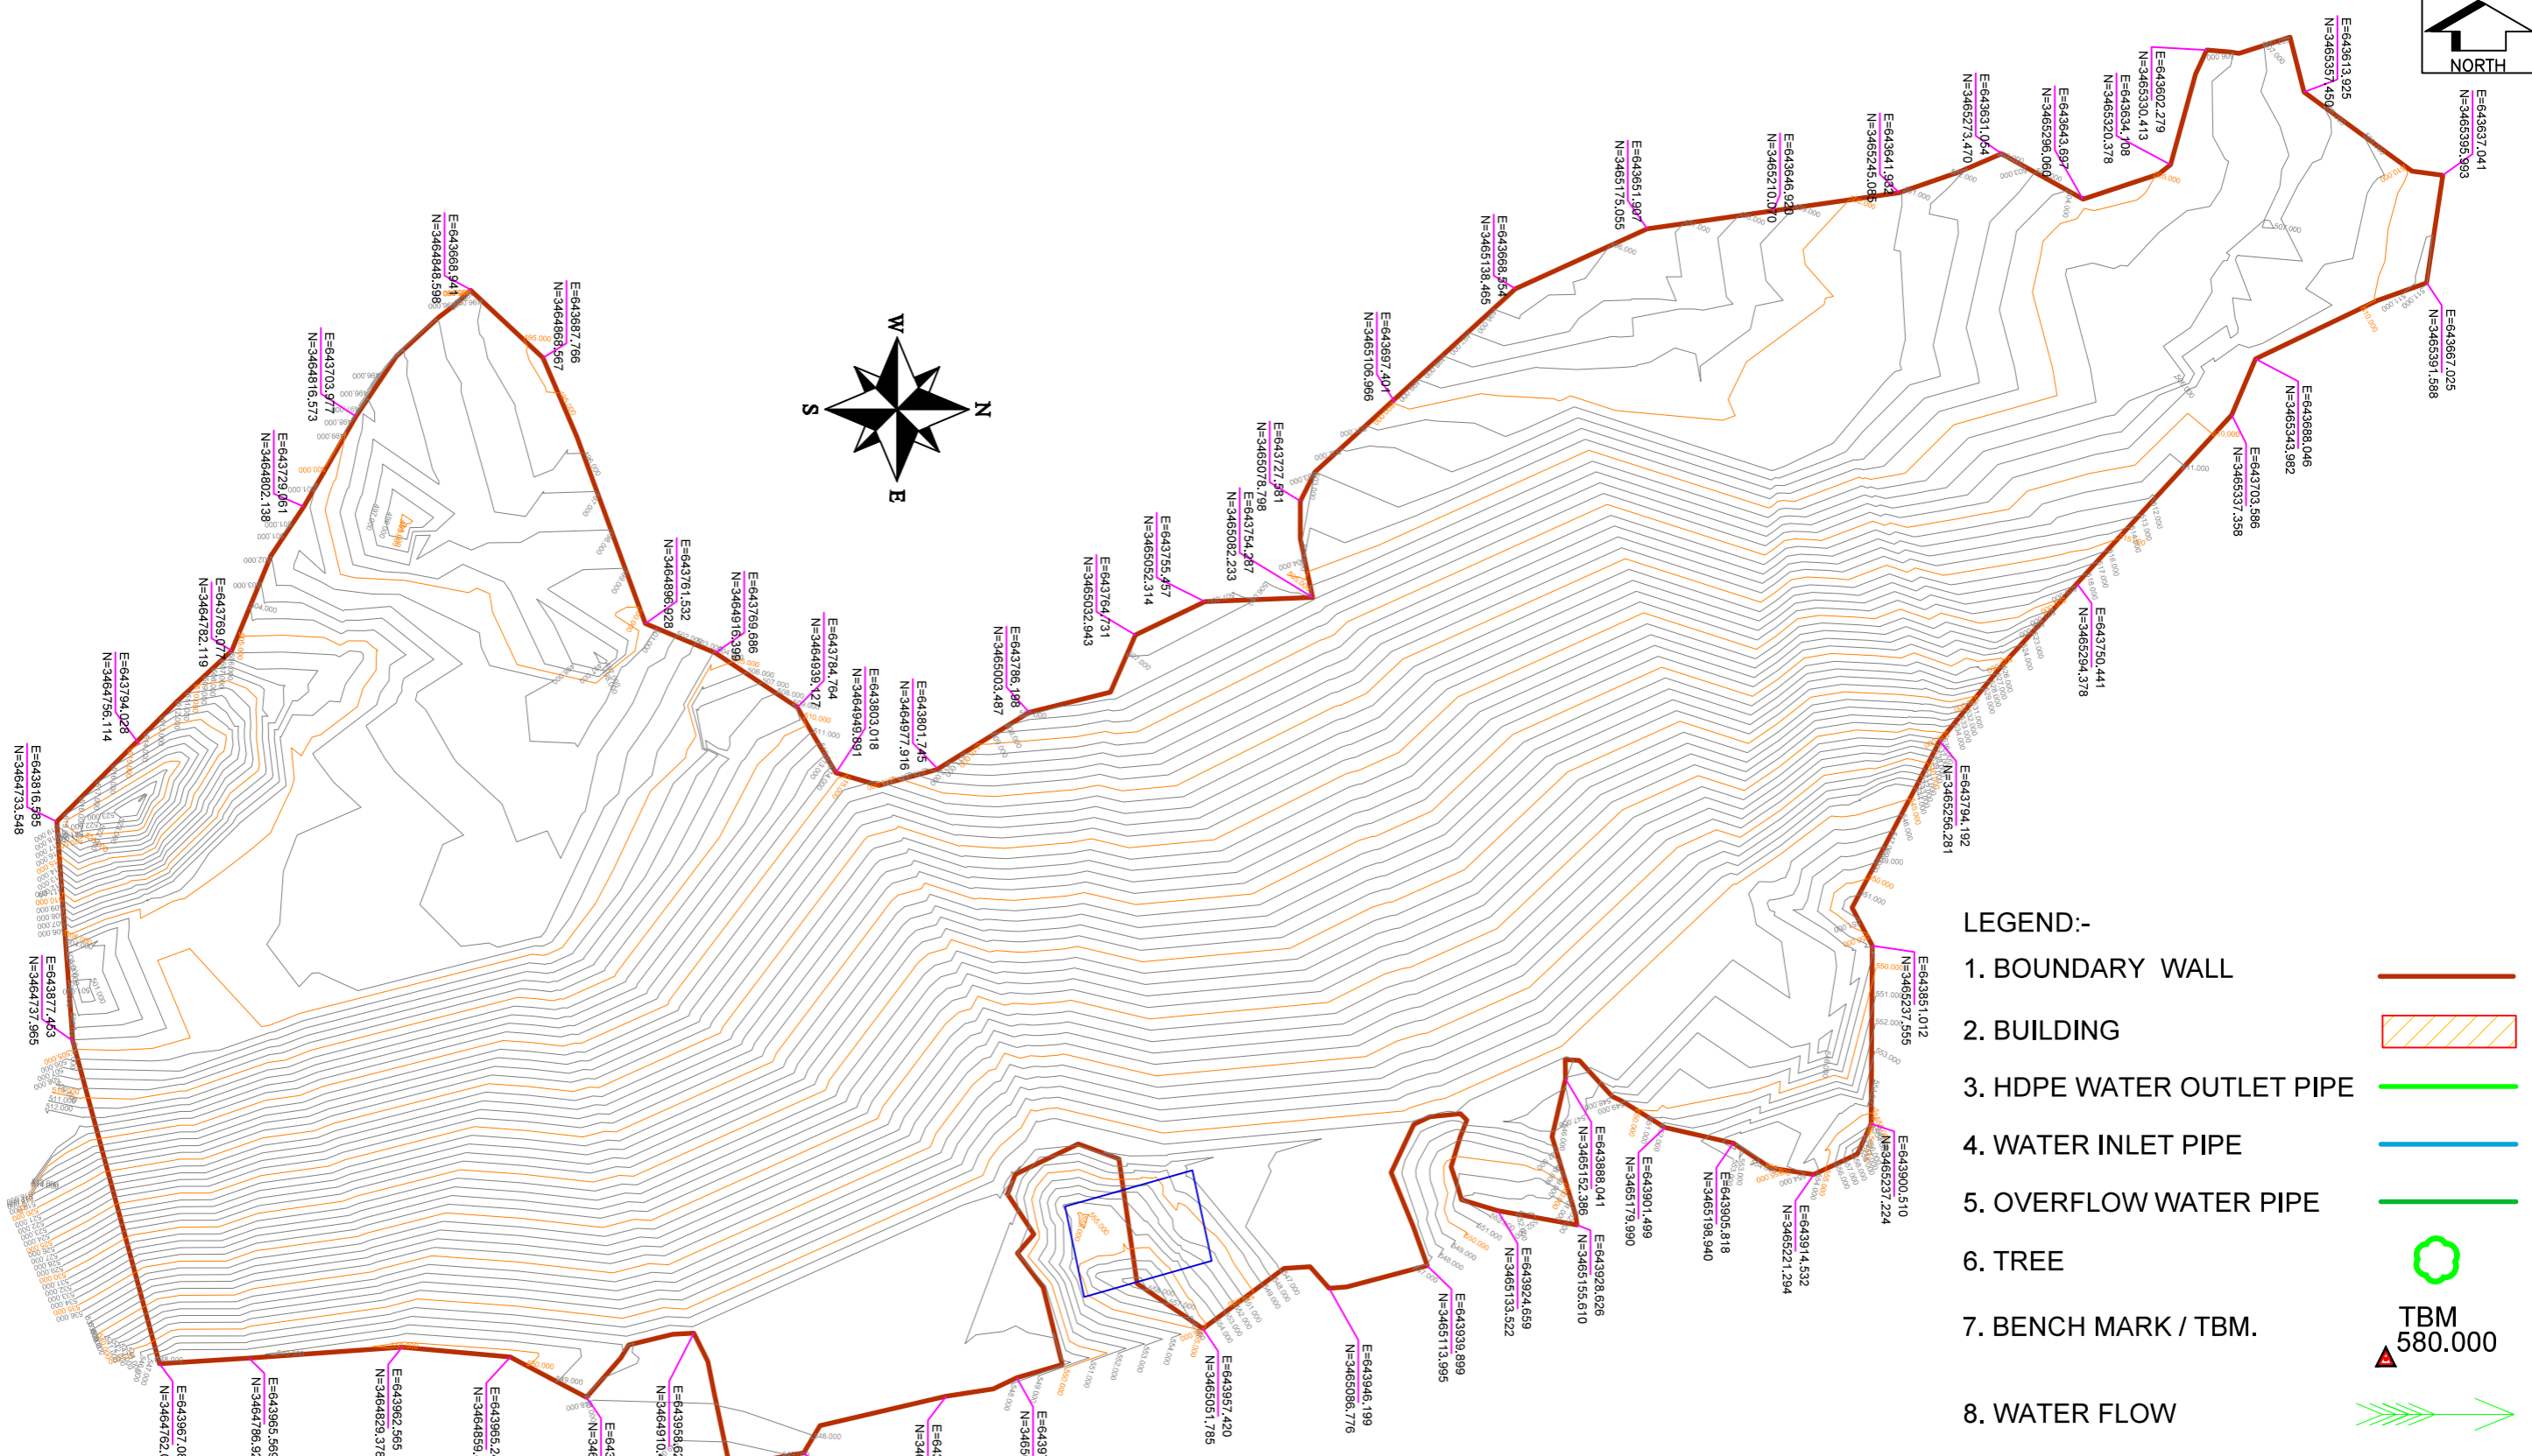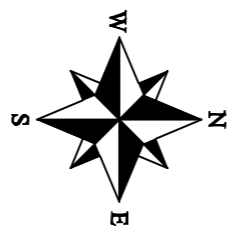

**LEGEND:-**

1. BOUNDARY WALL	
2. BUILDING	
3. HDPE WATER OUTLET PIPE	
4. WATER INLET PIPE	
5. OVERFLOW WATER PIPE	
6. TREE	
7. BENCH MARK / TBM.	
8. WATER FLOW	

TBM 580.000

DETAILED DESIGN CONSULTANCY, HP-SHIVA (PACKAGE CS09)  
IRRIGATION, HORTICULTURE, ORCHARDS AND VALUE CHAIN DEVELOPMENT

TOPOGRAPHICAL SURVEY FOR BASSI CLUSTER  
SWARGHAT BLOCK, BILASPUR DISTRICT

**TATA CONSULTING ENGINEERS LIMITED**  
MUMBAI

SIGN. OF CLIENT:-			
JE	AE	EE	SE
PURPOSE: FOR TENDER ONLY			
DO NOT SCALE			
<small>Proprietary Notice and Version Control: This document contains confidential information for use only by the Client. For the Project under consideration, which is provided for the sole purpose of permitting the recipient to evaluate the information submitted herewith, in consideration of receipt of this document, unless agreed to in contrary in the Contract, the recipient agrees to maintain such information in confidence and to not reproduce or otherwise disclose this information to any person outside the recipient's organization, except that there is no obligation to maintain the confidentiality of any information which was known to the recipient prior to receipt of such information from Tata Consulting Engineers Limited, or becomes publicly known through no fault of recipient, or Tata Consulting Engineers Limited, or is received without obligation of confidentiality from a third party owing no obligation of confidentiality to Tata Consulting Engineers Limited. All information given under this version over rides all and any kind of offers, assumptions, deliverables and contracts submitted verbally (and subsequently communicated in writing) or in writing or otherwise given under any and all previous version/s.</small>			
FILE NAME 12503A-CV-30062-Rev-P0			


'P' (PRELIMINARY) ISSUES ARE NOT TO BE USED FOR CONSTRUCTION / FABRICATION BUT ARE ISSUED FOR LIMITED PURPOSES ONLY AS INDICATED IN THE SMALL BLOCK ABOVE THIS BLOCK.

CONSTRUCTION / FABRICATION WORK IS PERMITTED ON 'R' (RELEASED) ISSUES ONLY.

INFORMATION CONTAINED WITHIN 'HOLD' IS NOT RELEASED FOR CONSTRUCTION / FABRICATION. FIELD MUST GET DESIGN OFFICE TO CLEAR 'HOLDS' IN TIME BEFORE PROCEEDING WITH ANY CONSTRUCTION/ FABRICATION WORK RELATED TO 'HOLDS'.

SIGN.											
	INITIALS										
REVISIONS											
	INITIALS										
PO	GKJ	ES	DVB						MK	DK	08-04-2022
	REVISIONS										
ISSUE	DRN	DSN	CHD	CV	EL	IC	ME		PE/PM	APPD	DATE (dd-mm-yyyy)
	CLEARED										

SCALE : NTS	DWG NO. TCE.12503A-CV-3005-LM-30062	ISSUE PO
DC & DISC: DEL-CV		

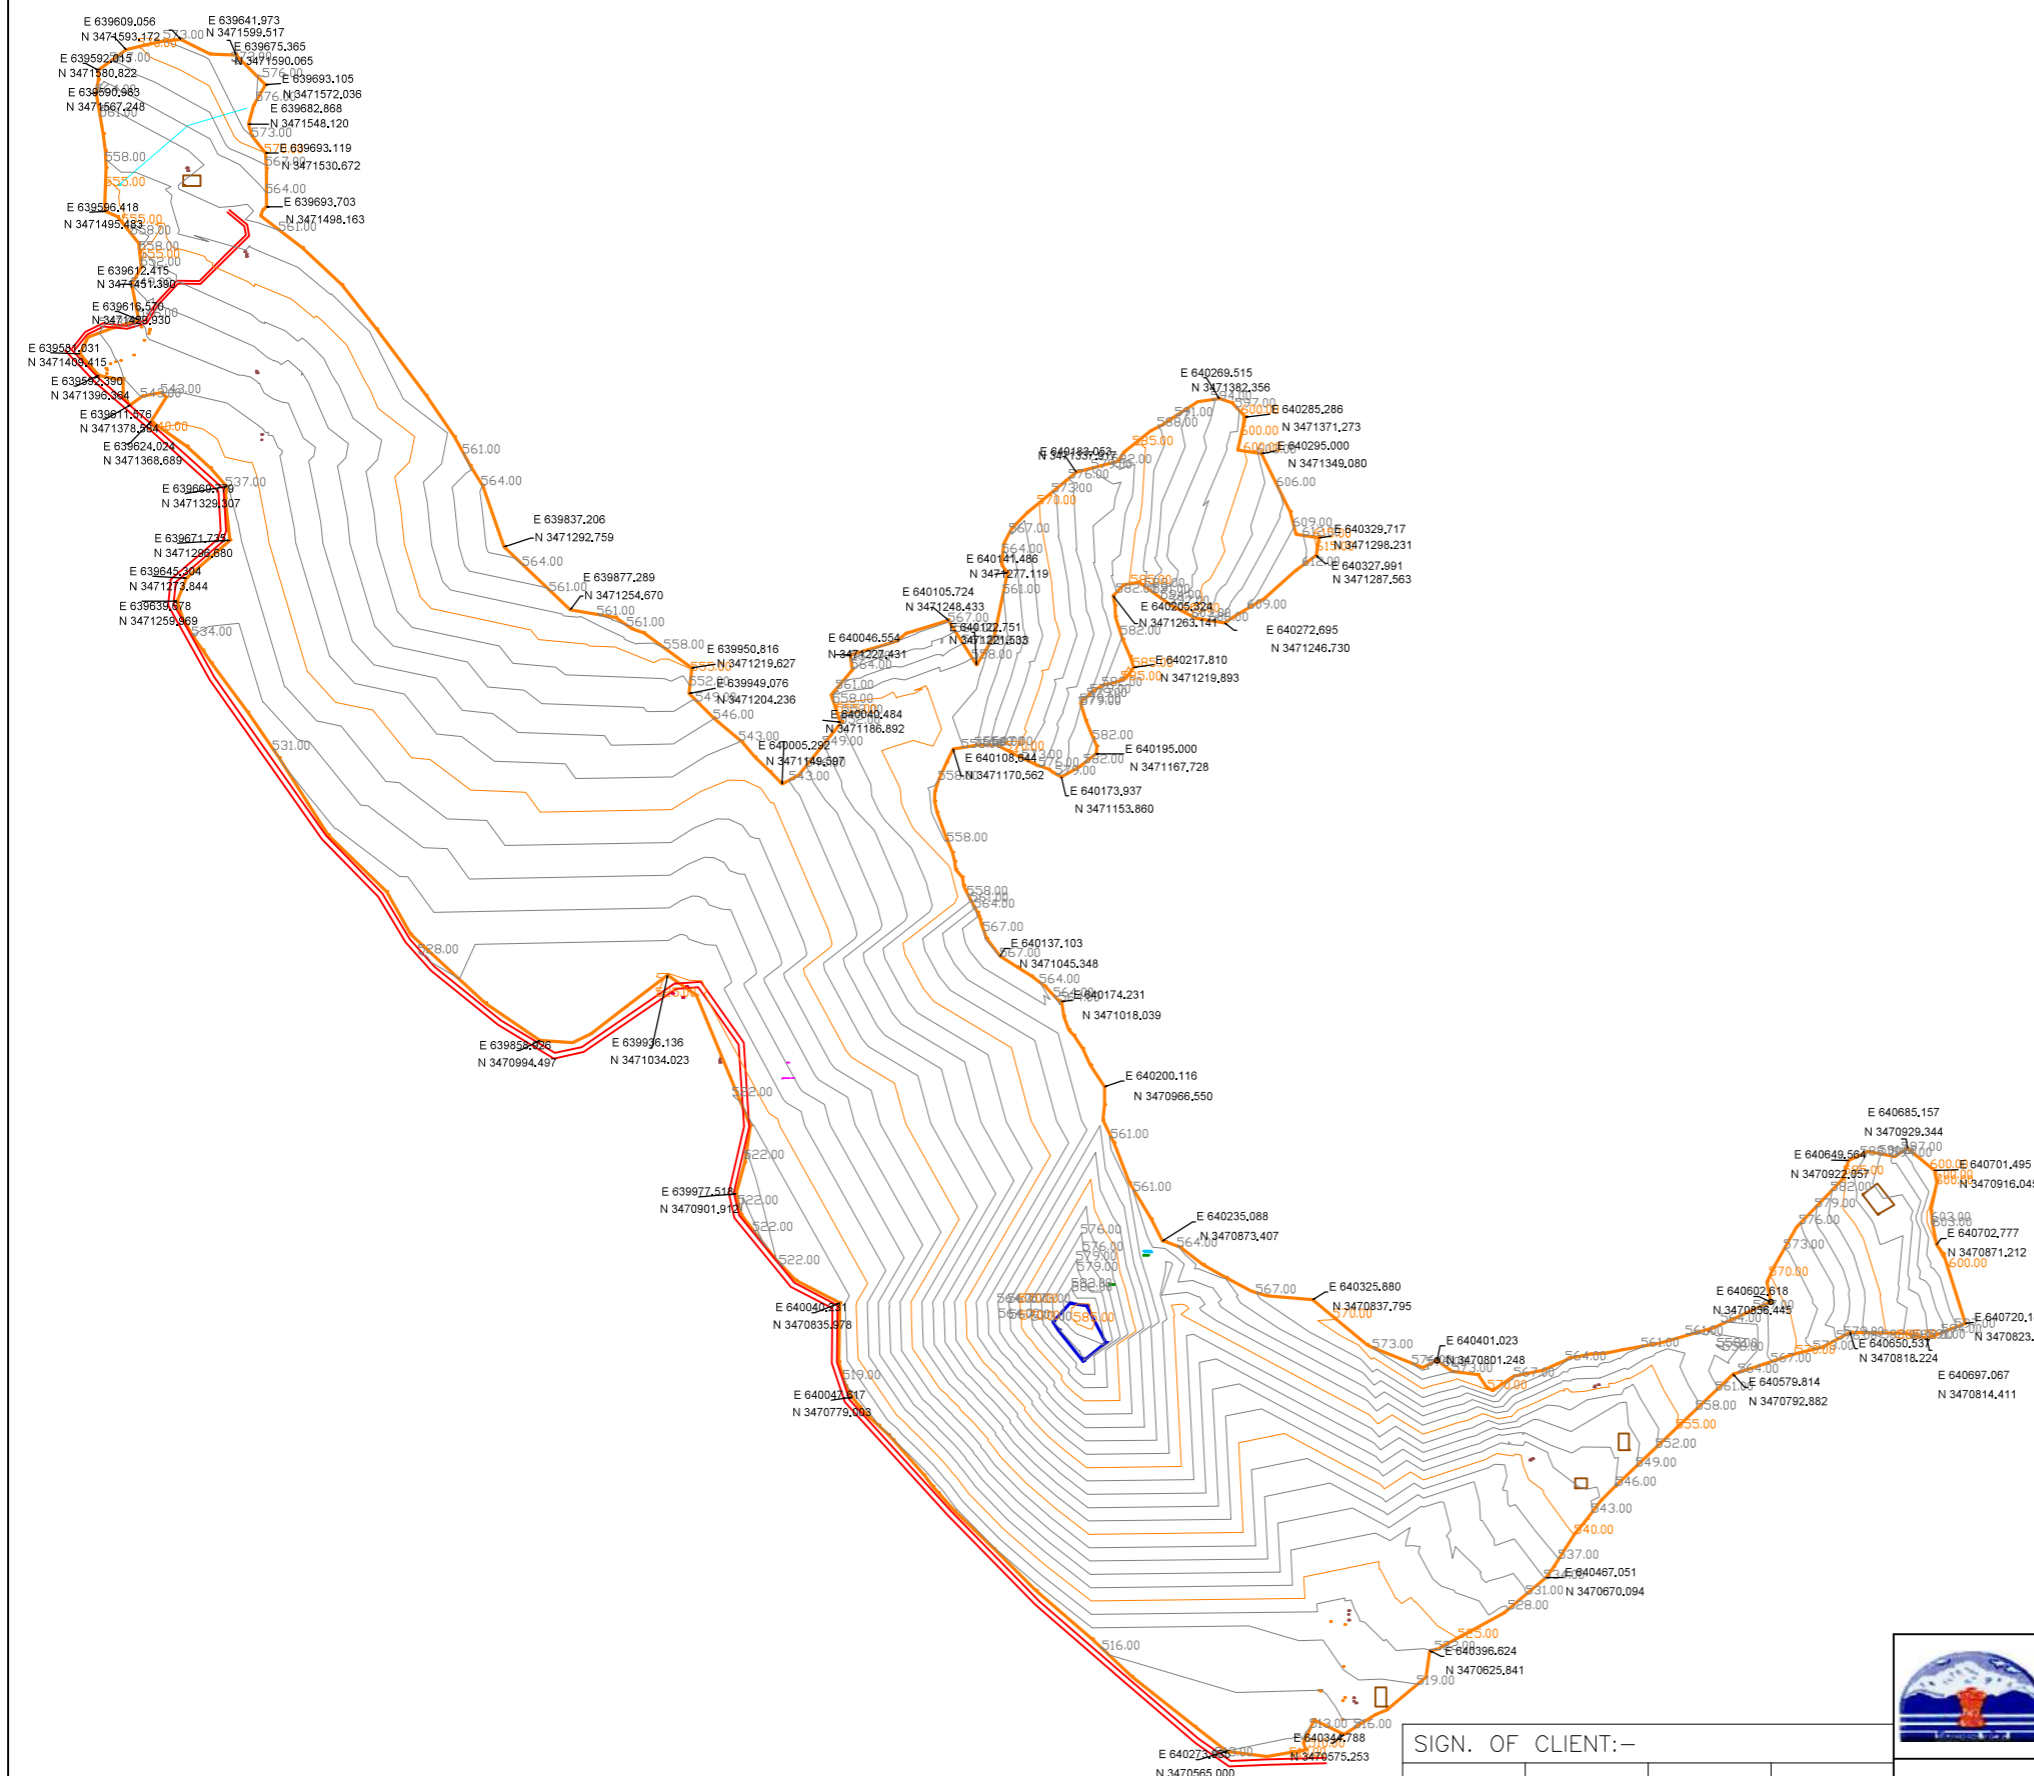

- LEGEND:-**
- 1. BOUNDARY WALL
  - 2. BUILDING
  - 3. HDPE WATER OUTLET PIPE
  - 4. WATER INLET PIPE
  - 5. OVERFLOW WATER PIPE
  - 6. TREE



DETAILED DESIGN CONSULTANCY, HP-SHIVA (PACKAGE CS09)  
IRRIGATION, HORTICULTURE, ORCHARDS AND VALUE CHAIN DEVELOPMENT

TOPOGRAPHICAL SURVEY FOR DULHET-3 CLUSTER  
SWARGHAT BLOCK, BILASPUR DISTRICT

SIGN. OF CLIENT:-

JE	AE	EE	SE
----	----	----	----

PURPOSE: FOR TENDER ONLY  
DO NOT SCALE

Proprietary Notice and Version Control: This document contains confidential information for use only by the Client; for the Project under consideration, which is provided for the sole purpose of permitting the recipient to evaluate the information submitted herewith. In consideration of receipt of this document, unless agreed to in contrary in the Contract, the recipient agrees to maintain such information in confidence and to not reproduce or otherwise disclose this information to any person outside the recipient's organization, except that there is no obligation to maintain the confidentiality of any information which was known to the recipient prior to receipt of such information from Tata Consulting Engineers Limited, or becomes publicly known through no fault of recipient, or Tata Consulting Engineers Limited, or is received without obligation of confidentiality from a third party owing no obligation of confidentiality to Tata Consulting Engineers Limited. All information given under this version over rides all and any kind of offers, assumptions, deliverables and contracts submitted verbally (and subsequently communicated in writing) or in writing or otherwise given under any and all previous versions.

**TATA CONSULTING ENGINEERS LIMITED**

MUMBAI

SCALE : NTS	DWG NO. TCE.12503A-CV-3005-LM-30063	ISSUE PO
-------------	-------------------------------------	----------

SIGN.												
	INITIALS											
	REVISIONS											
PO	SIGN.									DATE	08-04-2022	
	INITIALS	GKJ	ES	DVB							MK	DK
	REVISIONS											
ISSUE	DRN	DSN	CHD	CV	EL	IC	ME	PE/PM	APPD	DATE	(dd-mm-yyyy)	
	CLEARED											


'P' (PRELIMINARY) ISSUES ARE NOT TO BE USED FOR CONSTRUCTION / FABRICATION BUT ARE ISSUED FOR LIMITED PURPOSES ONLY AS INDICATED IN THE SMALL BLOCK ABOVE THIS BLOCK.

CONSTRUCTION / FABRICATION WORK IS PERMITTED ONLY FOR (RELEASED) ISSUES ONLY.

INFORMATION CONTAINED WITHIN 'HOLD' IS NOT RELEASED FOR CONSTRUCTION / FABRICATION. FIELD MUST GET DESIGN OFFICE TO CLEAR 'HOLDS' IN TIME BEFORE PROCEEDING WITH ANY CONSTRUCTION / FABRICATION WORK RELATED TO 'HOLDS'.

SIZE-A3



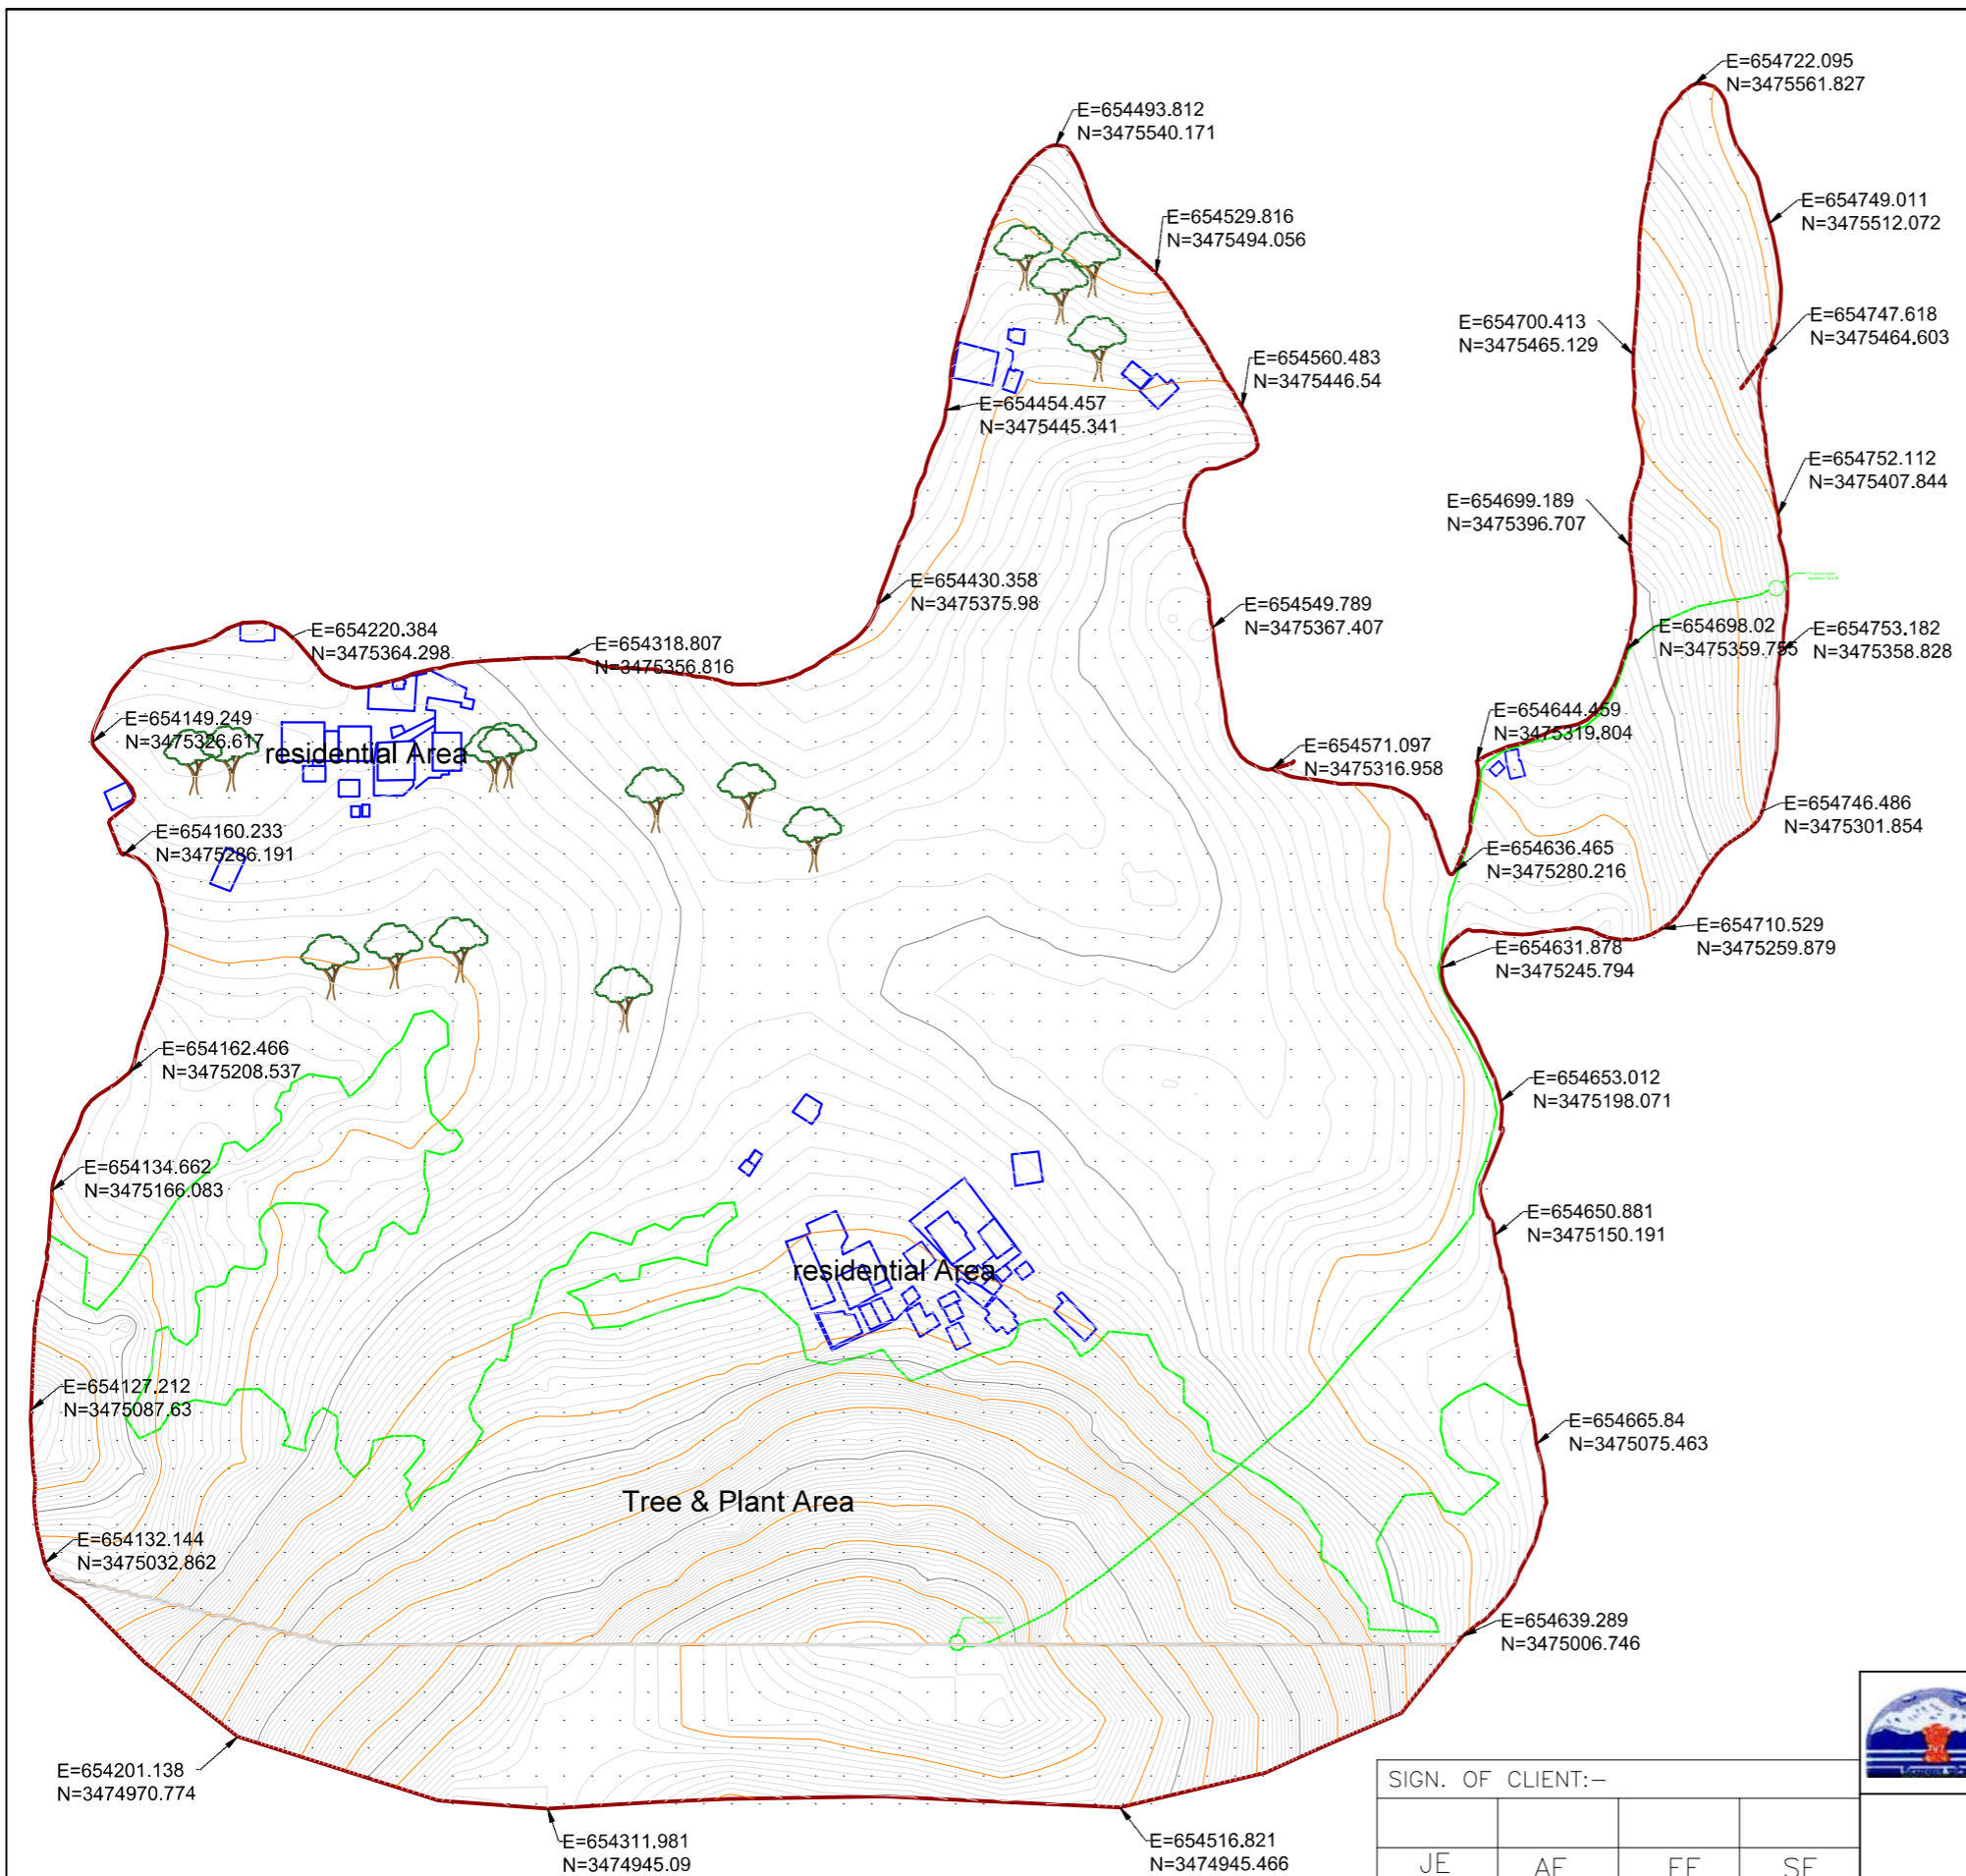

**LEGEND:-**

- 1. BOUNDRY WALL
- 2. BUILDING
- 3. HDPE WATER OUTLET PIPE
- 4. WATER INLET PIPE
- 5. OVERFLOW WATER PIPE
- 6. TREE
- 7. FLD
- 8. BENCH MARK / TBM.
- 9. WATER FLOW

SIGN.											
	INITIALS										
	REVISIONS										
PO	SIGN.										
	INITIALS	GKJ	ES	DVB					MK	DK	08-04-2022
	REVISIONS										
ISSUE	DRN	DSN	CHD	CV	EL	IC	ME		PE/PM	APPD	DATE (dd-mm-yyyy)
	CLEARED										

'P' (PRELIMINARY) ISSUES ARE NOT TO BE USED FOR CONSTRUCTION / FABRICATION BUT ARE ISSUED FOR LIMITED PURPOSES ONLY AS INDICATED IN THE SMALL BLOCK ABOVE THIS BLOCK.

CONSTRUCTION / FABRICATION WORK IS PERMITTED ON 'R' (RELEASED) ISSUES ONLY.

INFORMATION CONTAINED WITHIN 'HOLD' IS NOT RELEASED FOR CONSTRUCTION / FABRICATION. FIELD MUST GET DESIGN OFFICE TO CLEAR 'HOLDS' IN TIME BEFORE PROCEEDING WITH ANY CONSTRUCTION/ FABRICATION WORK RELATED TO 'HOLDS'.

SIGN. OF CLIENT:-			
JE	AE	EE	SE
PURPOSE: FOR TENDER ONLY			
DO NOT SCALE			
Proprietary Notice and Vendor Control: This document contains confidential information for use only by the Client. For the Project under consideration, which is provided for the sole purpose of permitting the recipient to evaluate the information submitted hereunder, in consideration of receipt of this document, unless agreed to in contrary in the Contract, the recipient agrees to maintain such information in confidence and to not reproduce or otherwise disclose this information to any person outside the recipient's organization; except that there is no obligation to maintain the confidentiality of any information which was known to the recipient prior to receipt of such information from Tata Consulting Engineers Limited, or becomes publicly known through no fault of recipient, or Tata Consulting Engineers Limited, or is received without obligation of confidentiality from a third party owing no obligation of confidentiality to Tata Consulting Engineers Limited. All information given under this version over rides all and any kind of offers, assumptions, deliverables and contracts submitted verbally (and subsequently communicated in writing) or in writing or otherwise given under any and all previous version/s.			
FILE NAME 12503A-CV-30064-Rev-P0			

**DETAILED DESIGN CONSULTANCY, HP-SHIVA (PACKAGE CS09)**  
 IRRIGATION, HORTICULTURE, ORCHARDS AND VALUE CHAIN DEVELOPMENT

---

**TOPOGRAPHICAL SURVEY FOR FAGOG CLUSTER**  
 JHANDUTTA BLOCK, BILASPUR DISTRICT

---


TATA CONSULTING ENGINEERS LIMITED

MUMBAI

---

SCALE : NTS	DWG NO. TCE.12503A-CV-3005-LM-30064	ISSUE PO
DC & DISC: DEL-CV		



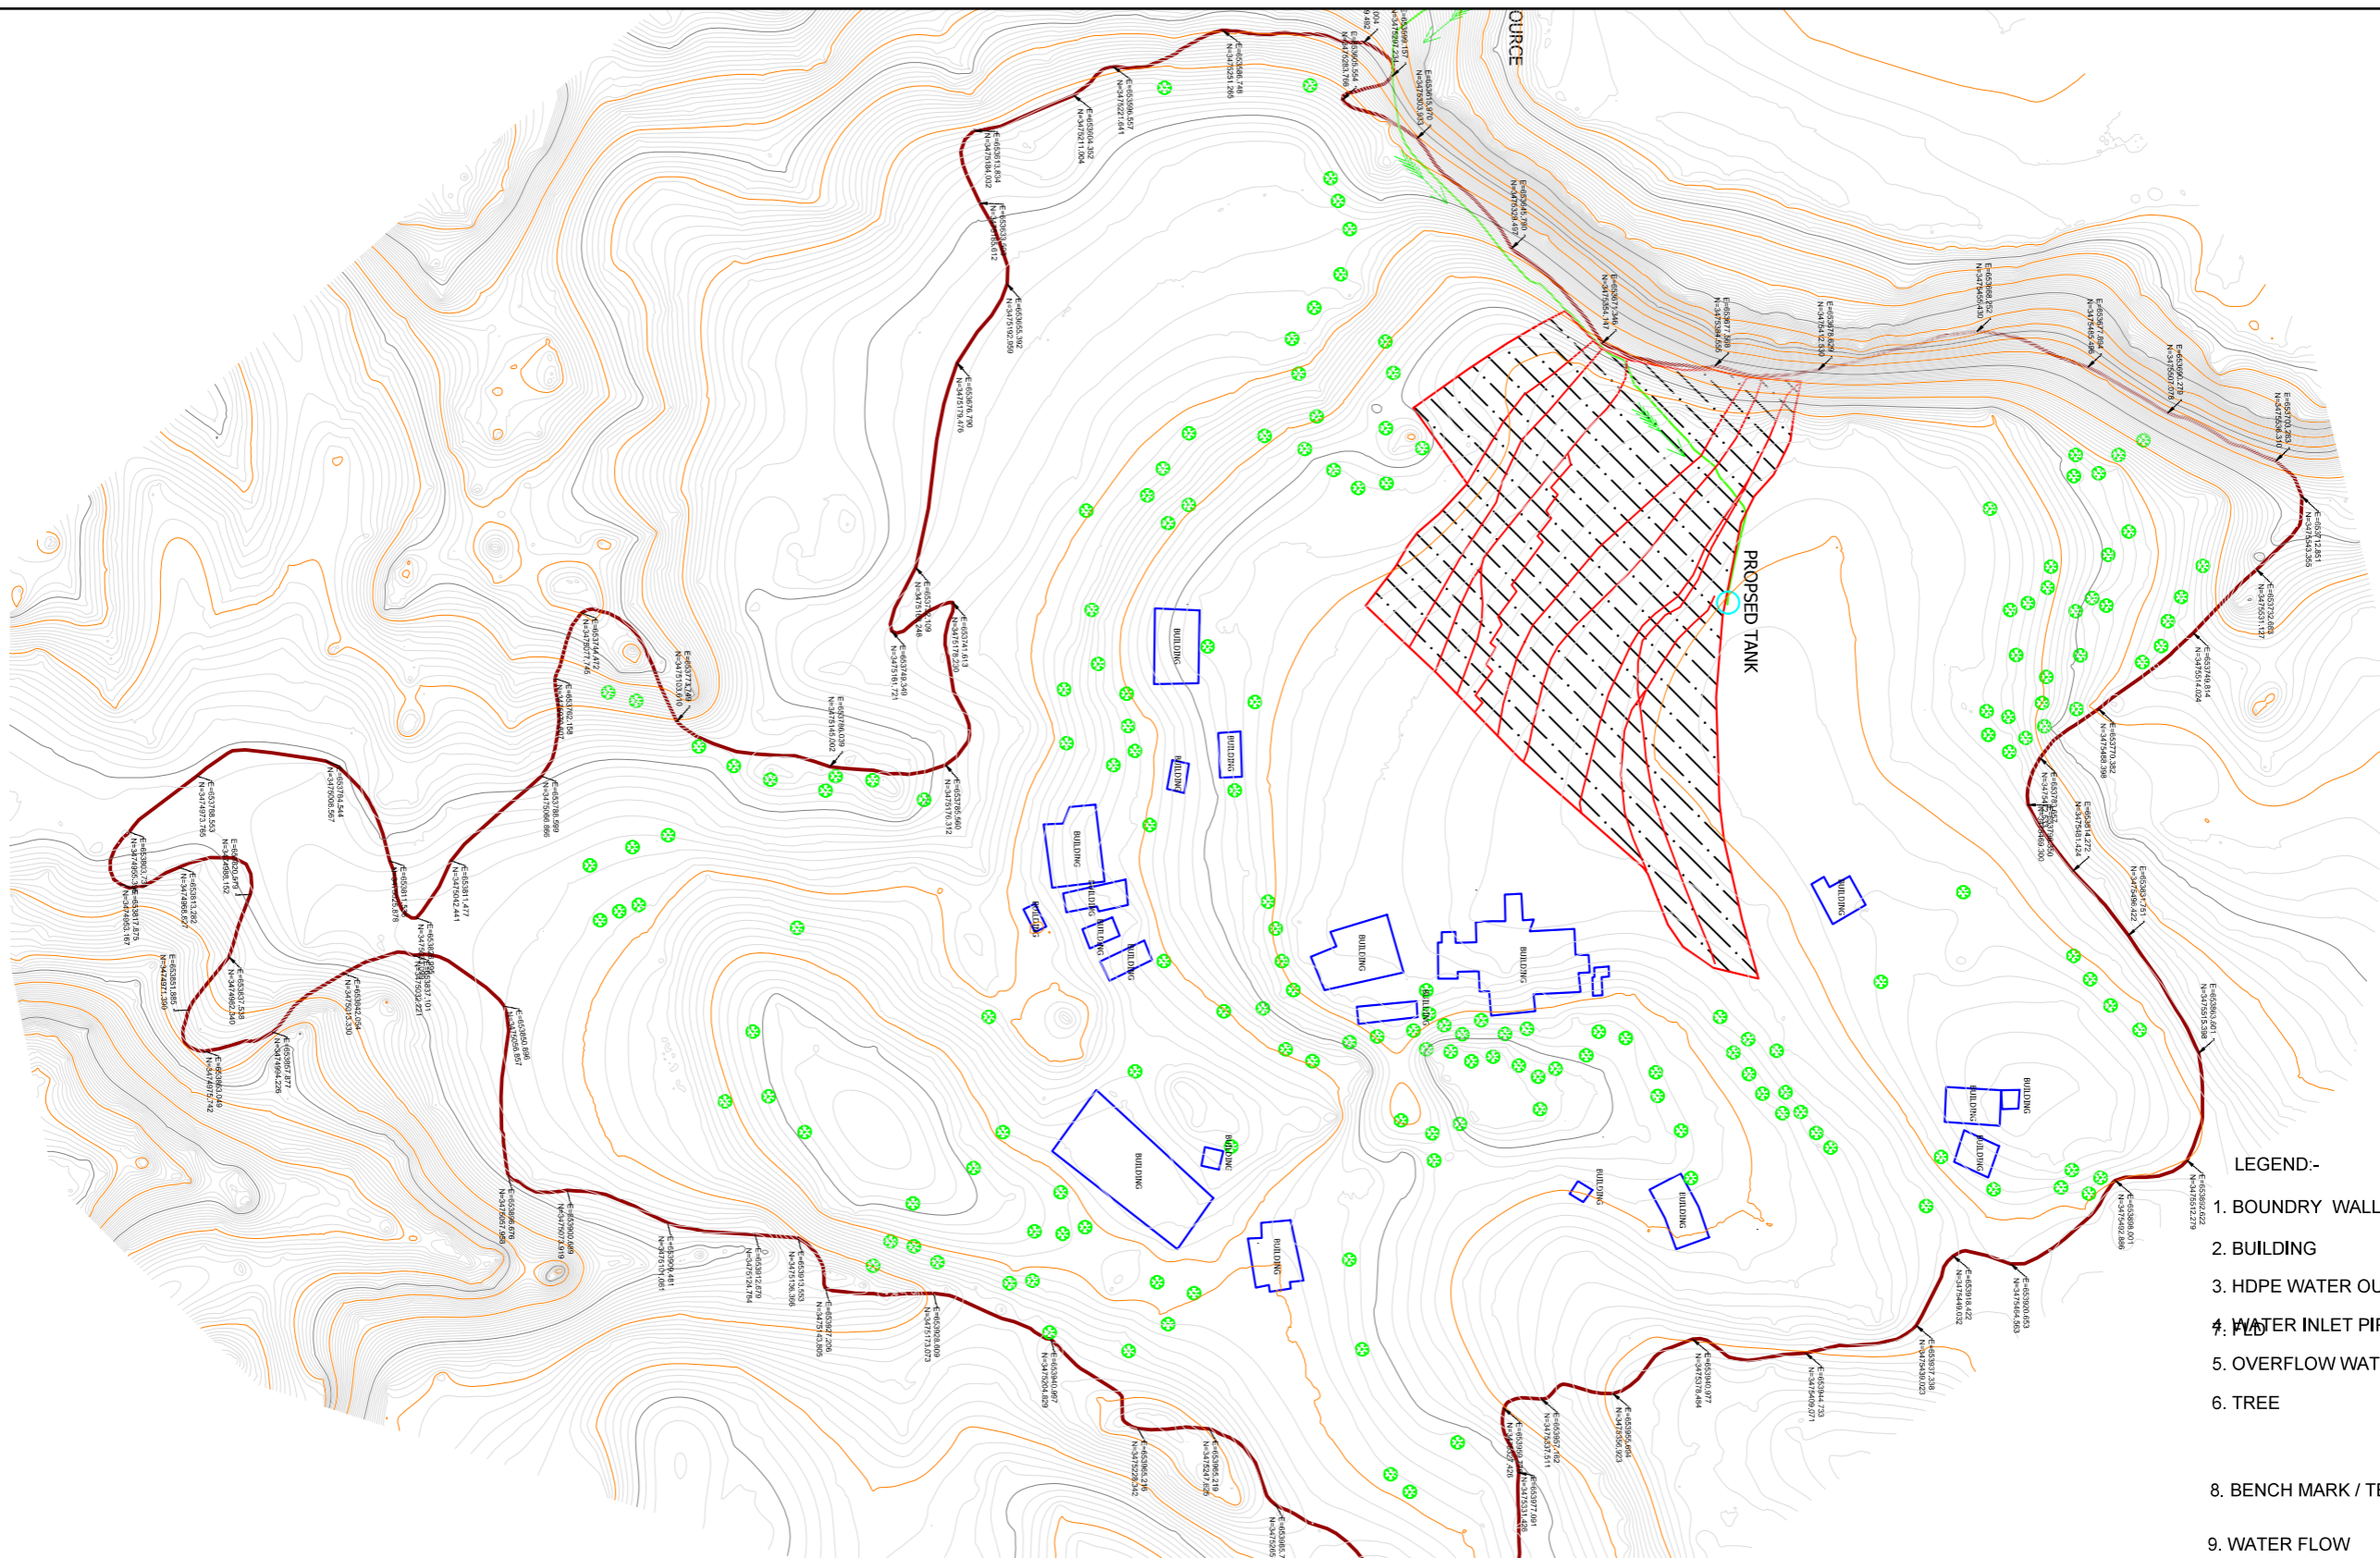

- LEGEND:-**
- 1. BOUNDRY WALL
  - 2. BUILDING
  - 3. HDPE WATER OUTLET PIPE
  - 4. WATER INLET PIPE
  - 5. OVERFLOW WATER PIPE
  - 6. TREE
  - 8. BENCH MARK / TBM.
  - 9. WATER FLOW

**DETAILED DESIGN CONSULTANCY, HP-SHIVA (PACKAGE CS09)**  
 IRRIGATION, HORTICULTURE, ORCHARDS AND VALUE CHAIN DEVELOPMENT


 
**TOPOGRAPHICAL SURVEY FOR FAGOG BANJHOLI CLUSTER**  
 JHANDUTTA BLOCK, BILASPUR DISTRICT

**TATA CONSULTING ENGINEERS LIMITED**  
 MUMBAI





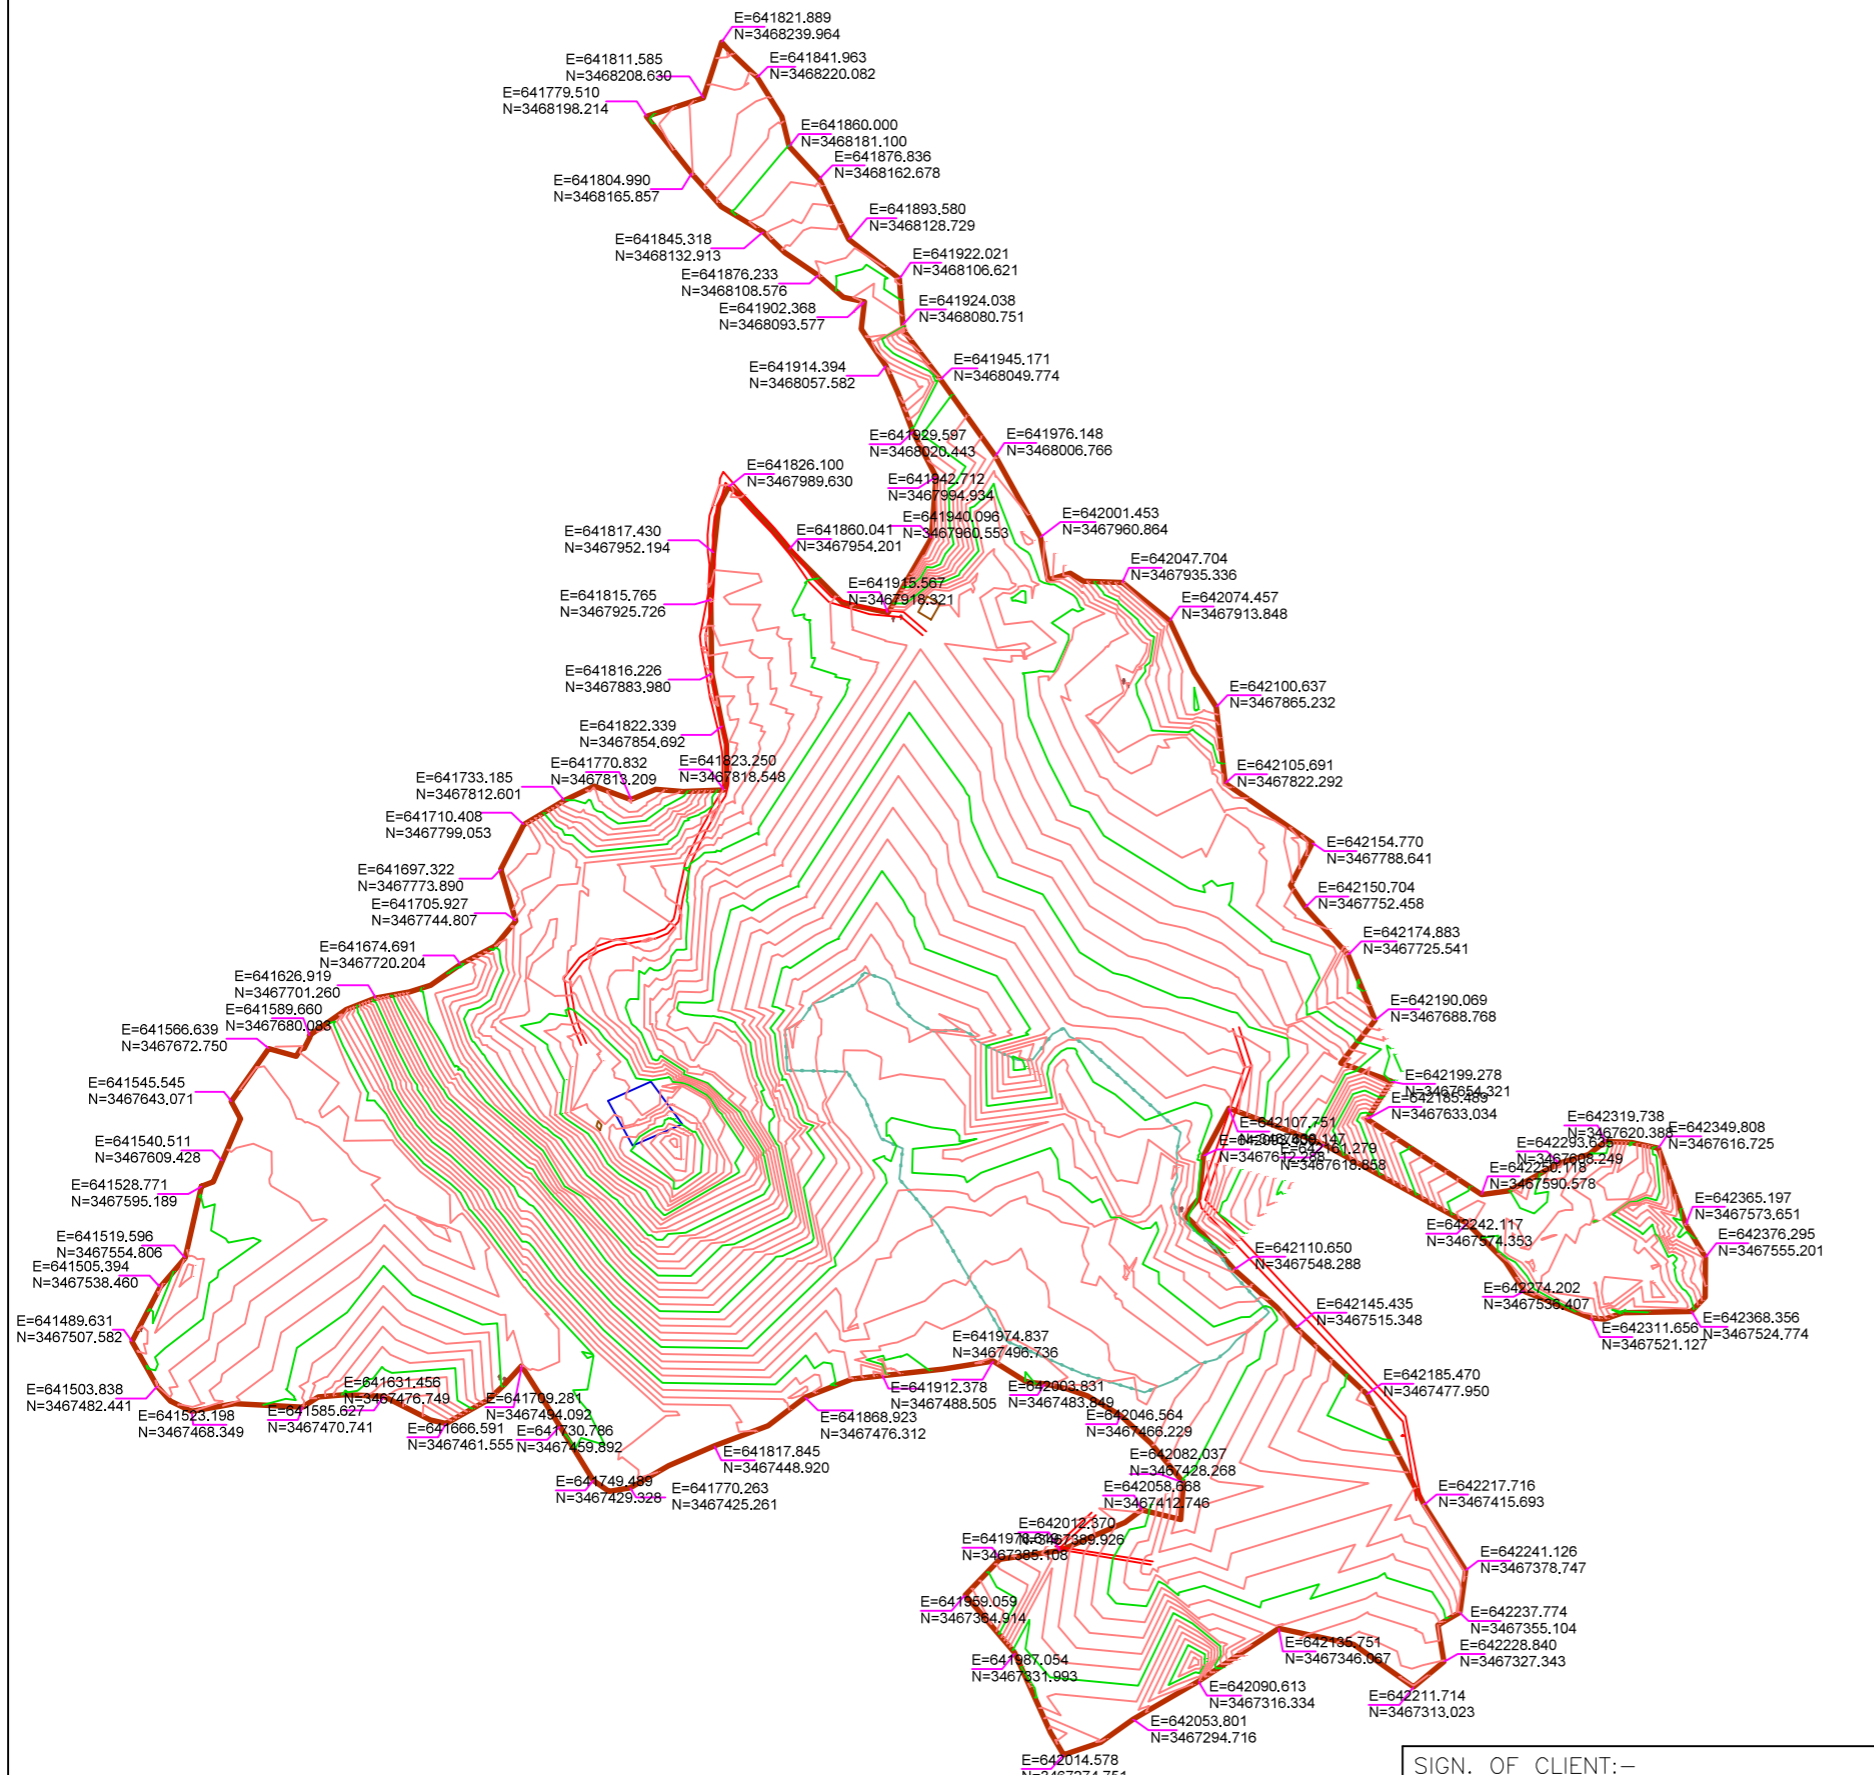


 
SIGN. OF CLIENT:-			
JE	AE	EE	SE
PURPOSE: FOR TENDER ONLY			
DO NOT SCALE			
Proprietary Notice and Vendor Control: This document contains confidential information for use only by the Client. For the Project under consideration, which is provided for the sole purpose of permitting the recipient to evaluate the information submitted hereunder, in consideration of receipt of this document, unless agreed to in contrary in the Contract, the recipient agrees to maintain such information in confidence and to not reproduce or otherwise disclose this information to any person outside the recipient's organization; except that there is no obligation to maintain the confidentiality of any information which was known to the recipient prior to receipt of such information from Tata Consulting Engineers Limited, or is received without obligation of confidentiality from a third party owing no obligation of confidentiality to Tata Consulting Engineers Limited. All information given under this version over rides all and any kind of offers, assumptions, deliverables and contracts submitted verbally (and subsequently communicated in writing) or in writing or otherwise given under any and all previous version/s.			
FILE NAME 12503A-CV-30065-Rev-P0			


SIGN.												
	INITIALS											
	REVISIONS											
PO	SIGN.											
	INITIALS	GKJ	ES	DVB				MK	DK	08-04-2022		
	REVISIONS											
ISSUE	DRN	DSN	CHD	CV	EL	IC	ME			PE/PM	APPD	DATE
	CLEARED											





LEGEND:-

- 1. BOUNDARY WALL 
- 2. BUILDING 
- 3. HDPE WATER OUTLET PIPE 
- 4. WATER INLET PIPE 
- 5. OVERFLOW WATER PIPE 
- 6. TREE 
- 7. BENCH MARK / TBM.   
TBM  
580.000
- 8. WATER FLOW 

 DETAILED DESIGN CONSULTANCY, HP-SHIVA (PACKAGE CS09)  
IRRIGATION, HORTICULTURE, ORCHARDS AND VALUE CHAIN DEVELOPMENT

TOPOGRAPHICAL SURVEY FOR GHATTEWAL CLUSTER  
SWARGHAT BLOCK, BILASPUR DISTRICT

 **TATA CONSULTING ENGINEERS LIMITED**  
MUMBAI

SIGN.										
	INITIALS									
	REVISIONS									
PO	SIGN.									
	INITIALS	GKJ	ES	DVB					MK	DK
	REVISIONS									
ISSUE	DRN	DSN	CHD	CV	EL	IC	ME	PE/PM	APPD	DATE
										(dd-mm-yyyy)

'P' (PRELIMINARY) ISSUES ARE NOT TO BE USED FOR CONSTRUCTION / FABRICATION BUT ARE ISSUED FOR LIMITED PURPOSES ONLY AS INDICATED IN THE SMALL BLOCK ABOVE THIS BLOCK.

CONSTRUCTION / FABRICATION WORK IS PERMITTED ON 'R' (RELEASED) ISSUES ONLY.

INFORMATION CONTAINED WITHIN 'HOLD' IS NOT RELEASED FOR CONSTRUCTION / FABRICATION. FIELD MUST GET DESIGN OFFICE TO CLEAR 'HOLD'S' IN TIME BEFORE PROCEEDING WITH ANY CONSTRUCTION/ FABRICATION WORK RELATED TO 'HOLD'S'.

SIGN. OF CLIENT:-


JE	AE	EE	SE
----	----	----	----

PURPOSE: FOR TENDER ONLY  
DO NOT SCALE

Proprietary Notice and/or Confidentiality: This document contains confidential information for use only by the Client. For the Project under consideration, which is provided for the sole purpose of permitting the recipient to evaluate the information submitted hereunder, in consideration of receipt of this document, unless agreed to in contrary in the Contract, the recipient agrees to maintain such information in confidence and to not reproduce or otherwise disclose this information to any person outside the recipient's organization, except that there is no obligation to maintain the confidentiality of any information which was known to the recipient prior to receipt of such information from Tata Consulting Engineers Limited, or becomes publicly known through no fault of recipient, or Tata Consulting Engineers Limited, or is received without obligation of confidentiality from a third party owing no obligation of confidentiality to Tata Consulting Engineers Limited. All information given under this version over rides all and any kind of offers, assumptions, deliverables and contracts submitted verbally (and subsequently communicated in writing) or in writing or otherwise given under any and all previous version/s.



FILE NAME 12503A-CV-30066--Rev--P0

SCALE : NTS	DWG NO. TCE.12503A-CV-3005-LM-30066	ISSUE PO
DC & DISC: DEL-CV		

 

LEGEND:-

- 1. BOUNDRY WALL
- 2. BUILDING
- 3. HDPE WATER OUTLET PIPE
- 4. WATER INLET PIPE
- 5. OVERFLOW WATER PIPE
- 6. TREE
- 7. FLD
- 8. BENCH MARK / TBM TBM 580.000
- 9. WATER FLOW

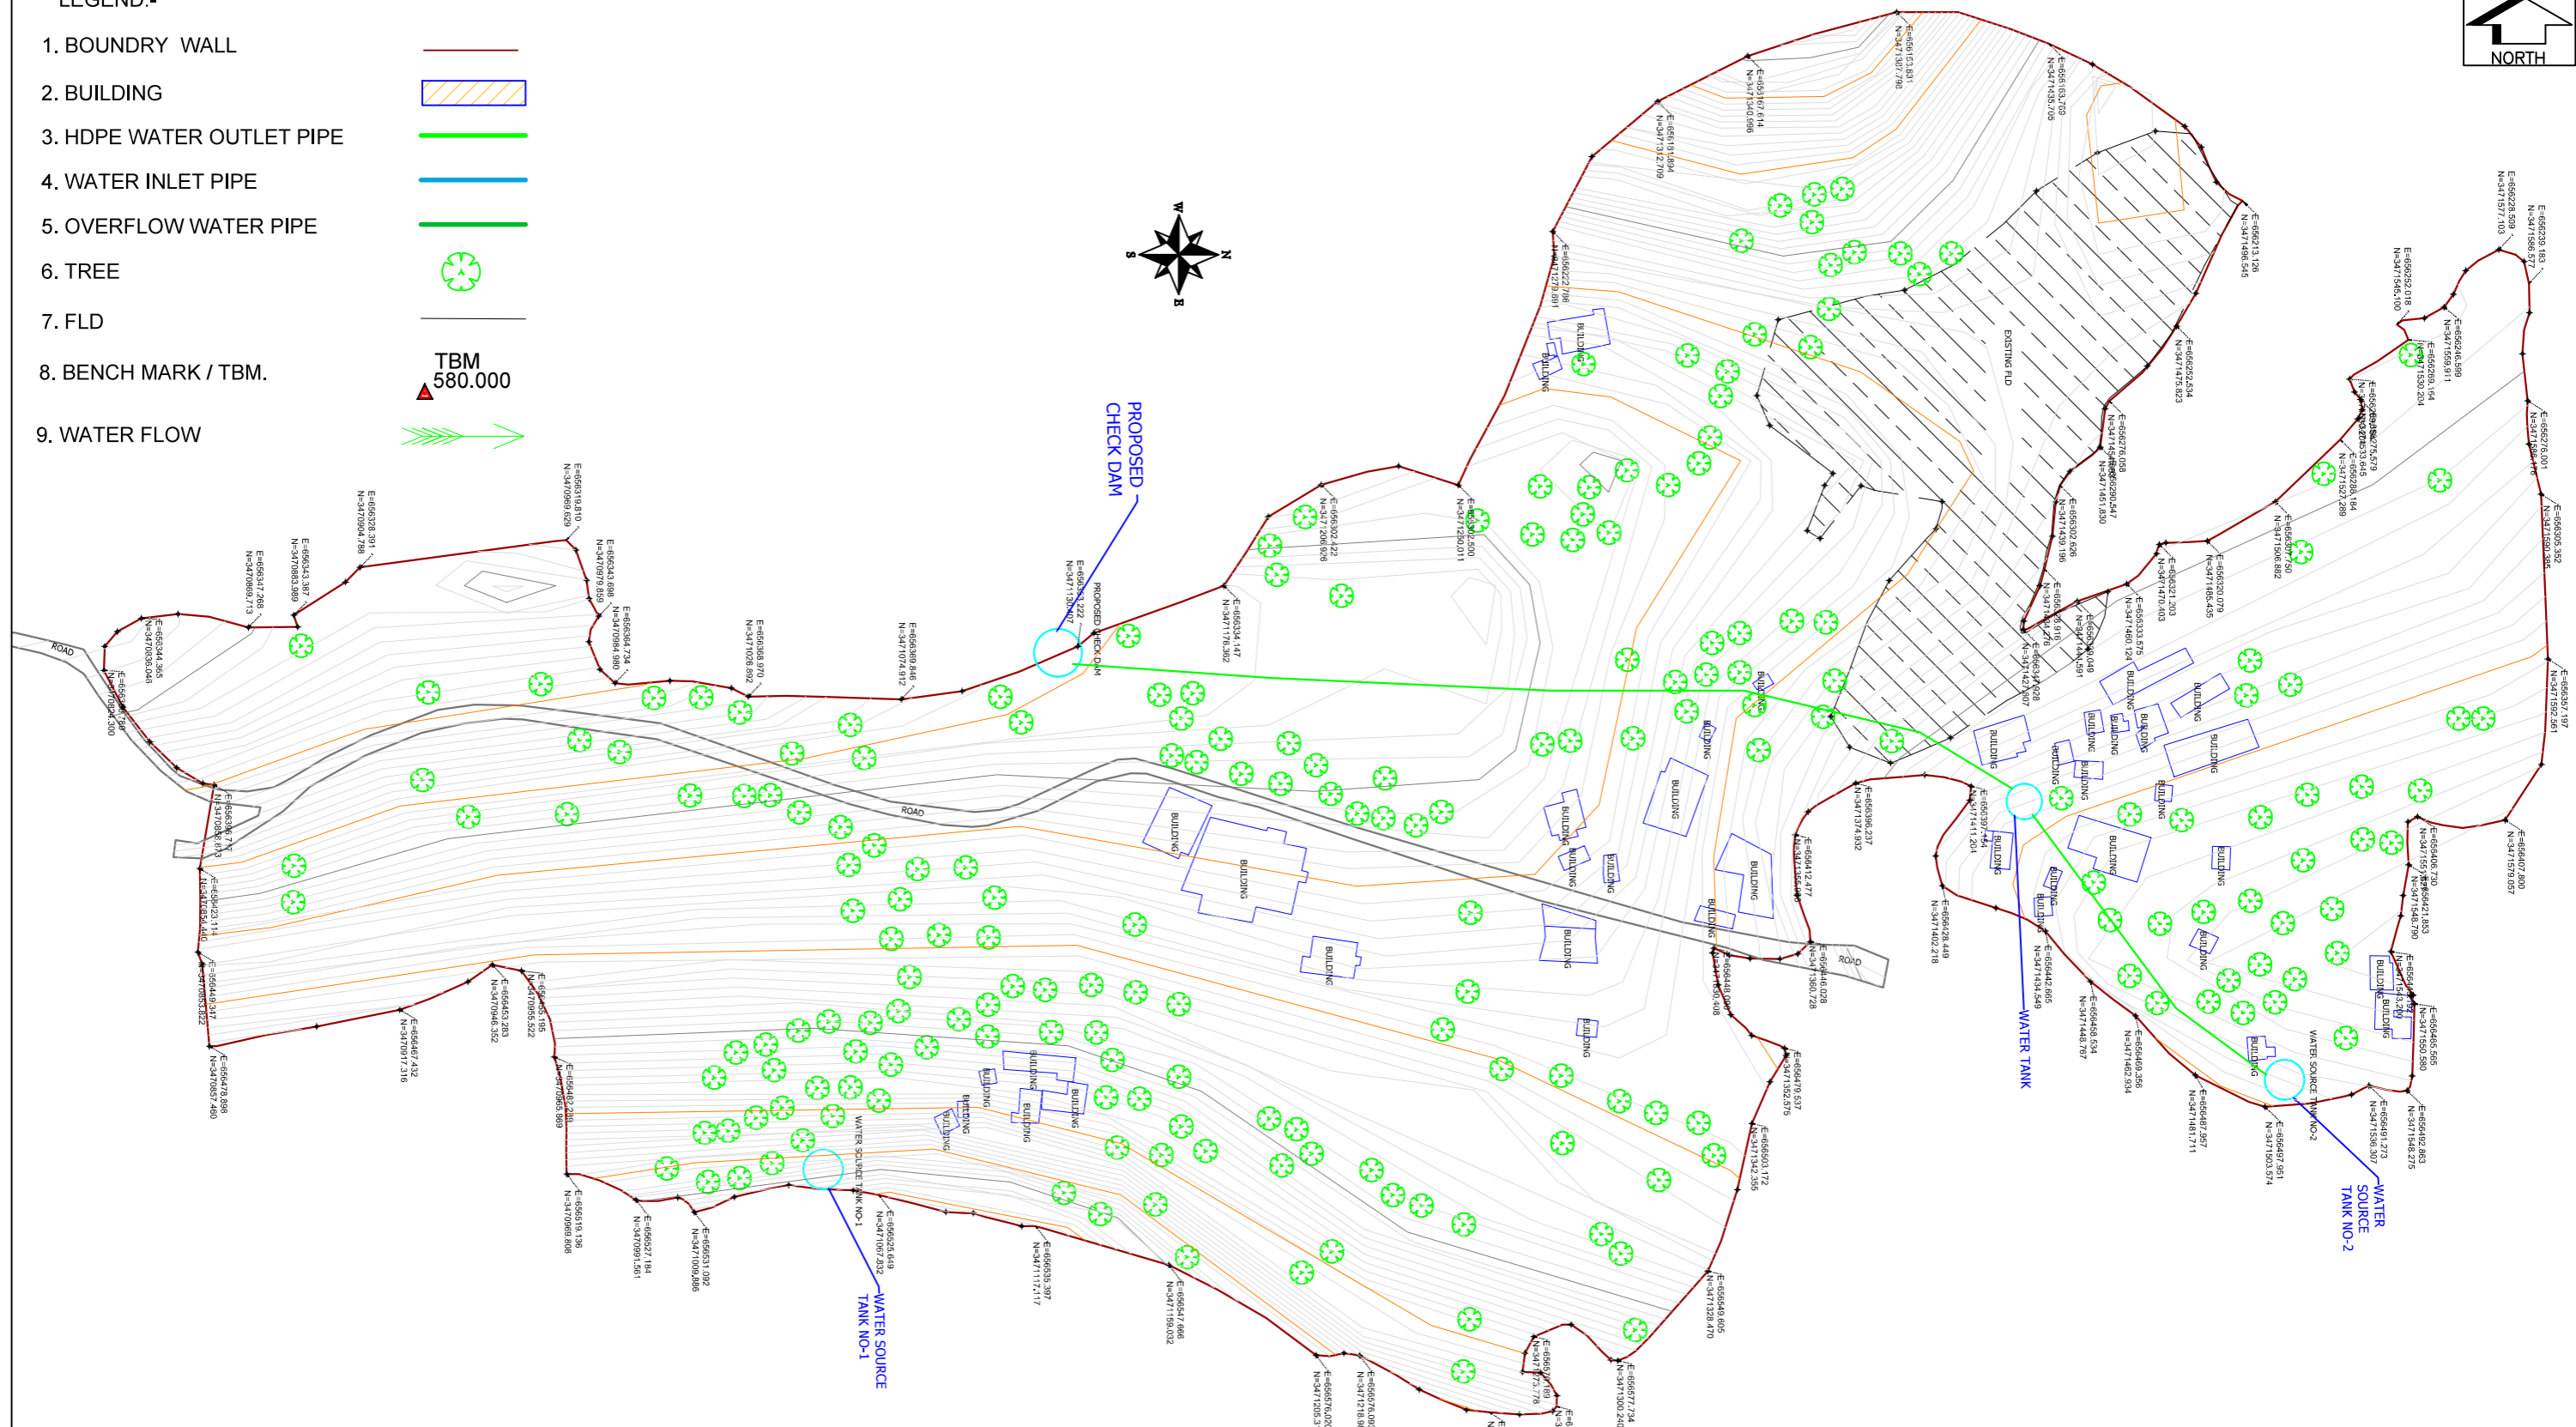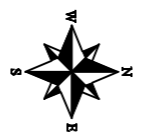

DETAILED DESIGN CONSULTANCY, HP-SHIVA (PACKAGE CS09)  
IRRIGATION, HORTICULTURE, ORCHARDS AND VALUE CHAIN DEVELOPMENT

TOPOGRAPHICAL SURVEY FOR JHANDU CLUSTER  
JHANDUTTA BLOCK, BILASPUR DISTRICT

SIGN. OF CLIENT:-

JE	AE	EE	SE
----	----	----	----

PURPOSE: FOR TENDER ONLY  
DO NOT SCALE

Proprietary Notice and Version Control: This document contains confidential information for use only by the Client. For the Project under consideration, which is provided for the sole purpose of permitting the recipient to evaluate the information submitted hereunder, in consideration of receipt of this document, unless agreed to in writing in the Contract, the recipient agrees to maintain such information in confidence and to not reproduce or otherwise disclose this information to any person outside the recipient's organization except that there is no obligation to maintain the confidentiality of any information which was known to the recipient prior to receipt of such information from Tata Consulting Engineers Limited, or becomes publicly known through no fault of recipient, or Tata Consulting Engineers Limited, or is received without obligation of confidentiality from a third party owing no obligation of confidentiality to Tata Consulting Engineers Limited. All information given under this version over rides all and any kind of offers, assumptions, deliverables and contracts submitted verbally (and subsequently communicated in writing) or in writing or otherwise given under any and all previous versions.



**TATA CONSULTING ENGINEERS LIMITED**  
MUMBAI

SCALE : NTS  
DC & DISC: DEL-CV

DWG NO. TCE.12503A-CV-3005-LM-30067  
ISSUE PO


SIGN.										
	INITIALS									
PO										
	INITIALS									
ISSUE										
	INITIALS									

'P' (PRELIMINARY) ISSUES ARE NOT TO BE USED FOR CONSTRUCTION / FABRICATION BUT ARE ISSUED FOR LIMITED PURPOSES ONLY AS INDICATED IN THE SMALL BLOCK ABOVE THIS BLOCK.

CONSTRUCTION / FABRICATION WORK IS PERMITTED ON 'R' (RELEASED) ISSUES ONLY.

INFORMATION CONTAINED WITHIN 'HOLD' IS NOT RELEASED FOR CONSTRUCTION / FABRICATION. FIELD MUST GET DESIGN OFFICE TO CLEAR 'HOLDS' IN TIME BEFORE PROCEEDING WITH ANY CONSTRUCTION/ FABRICATION WORK RELATED TO 'HOLDS'.



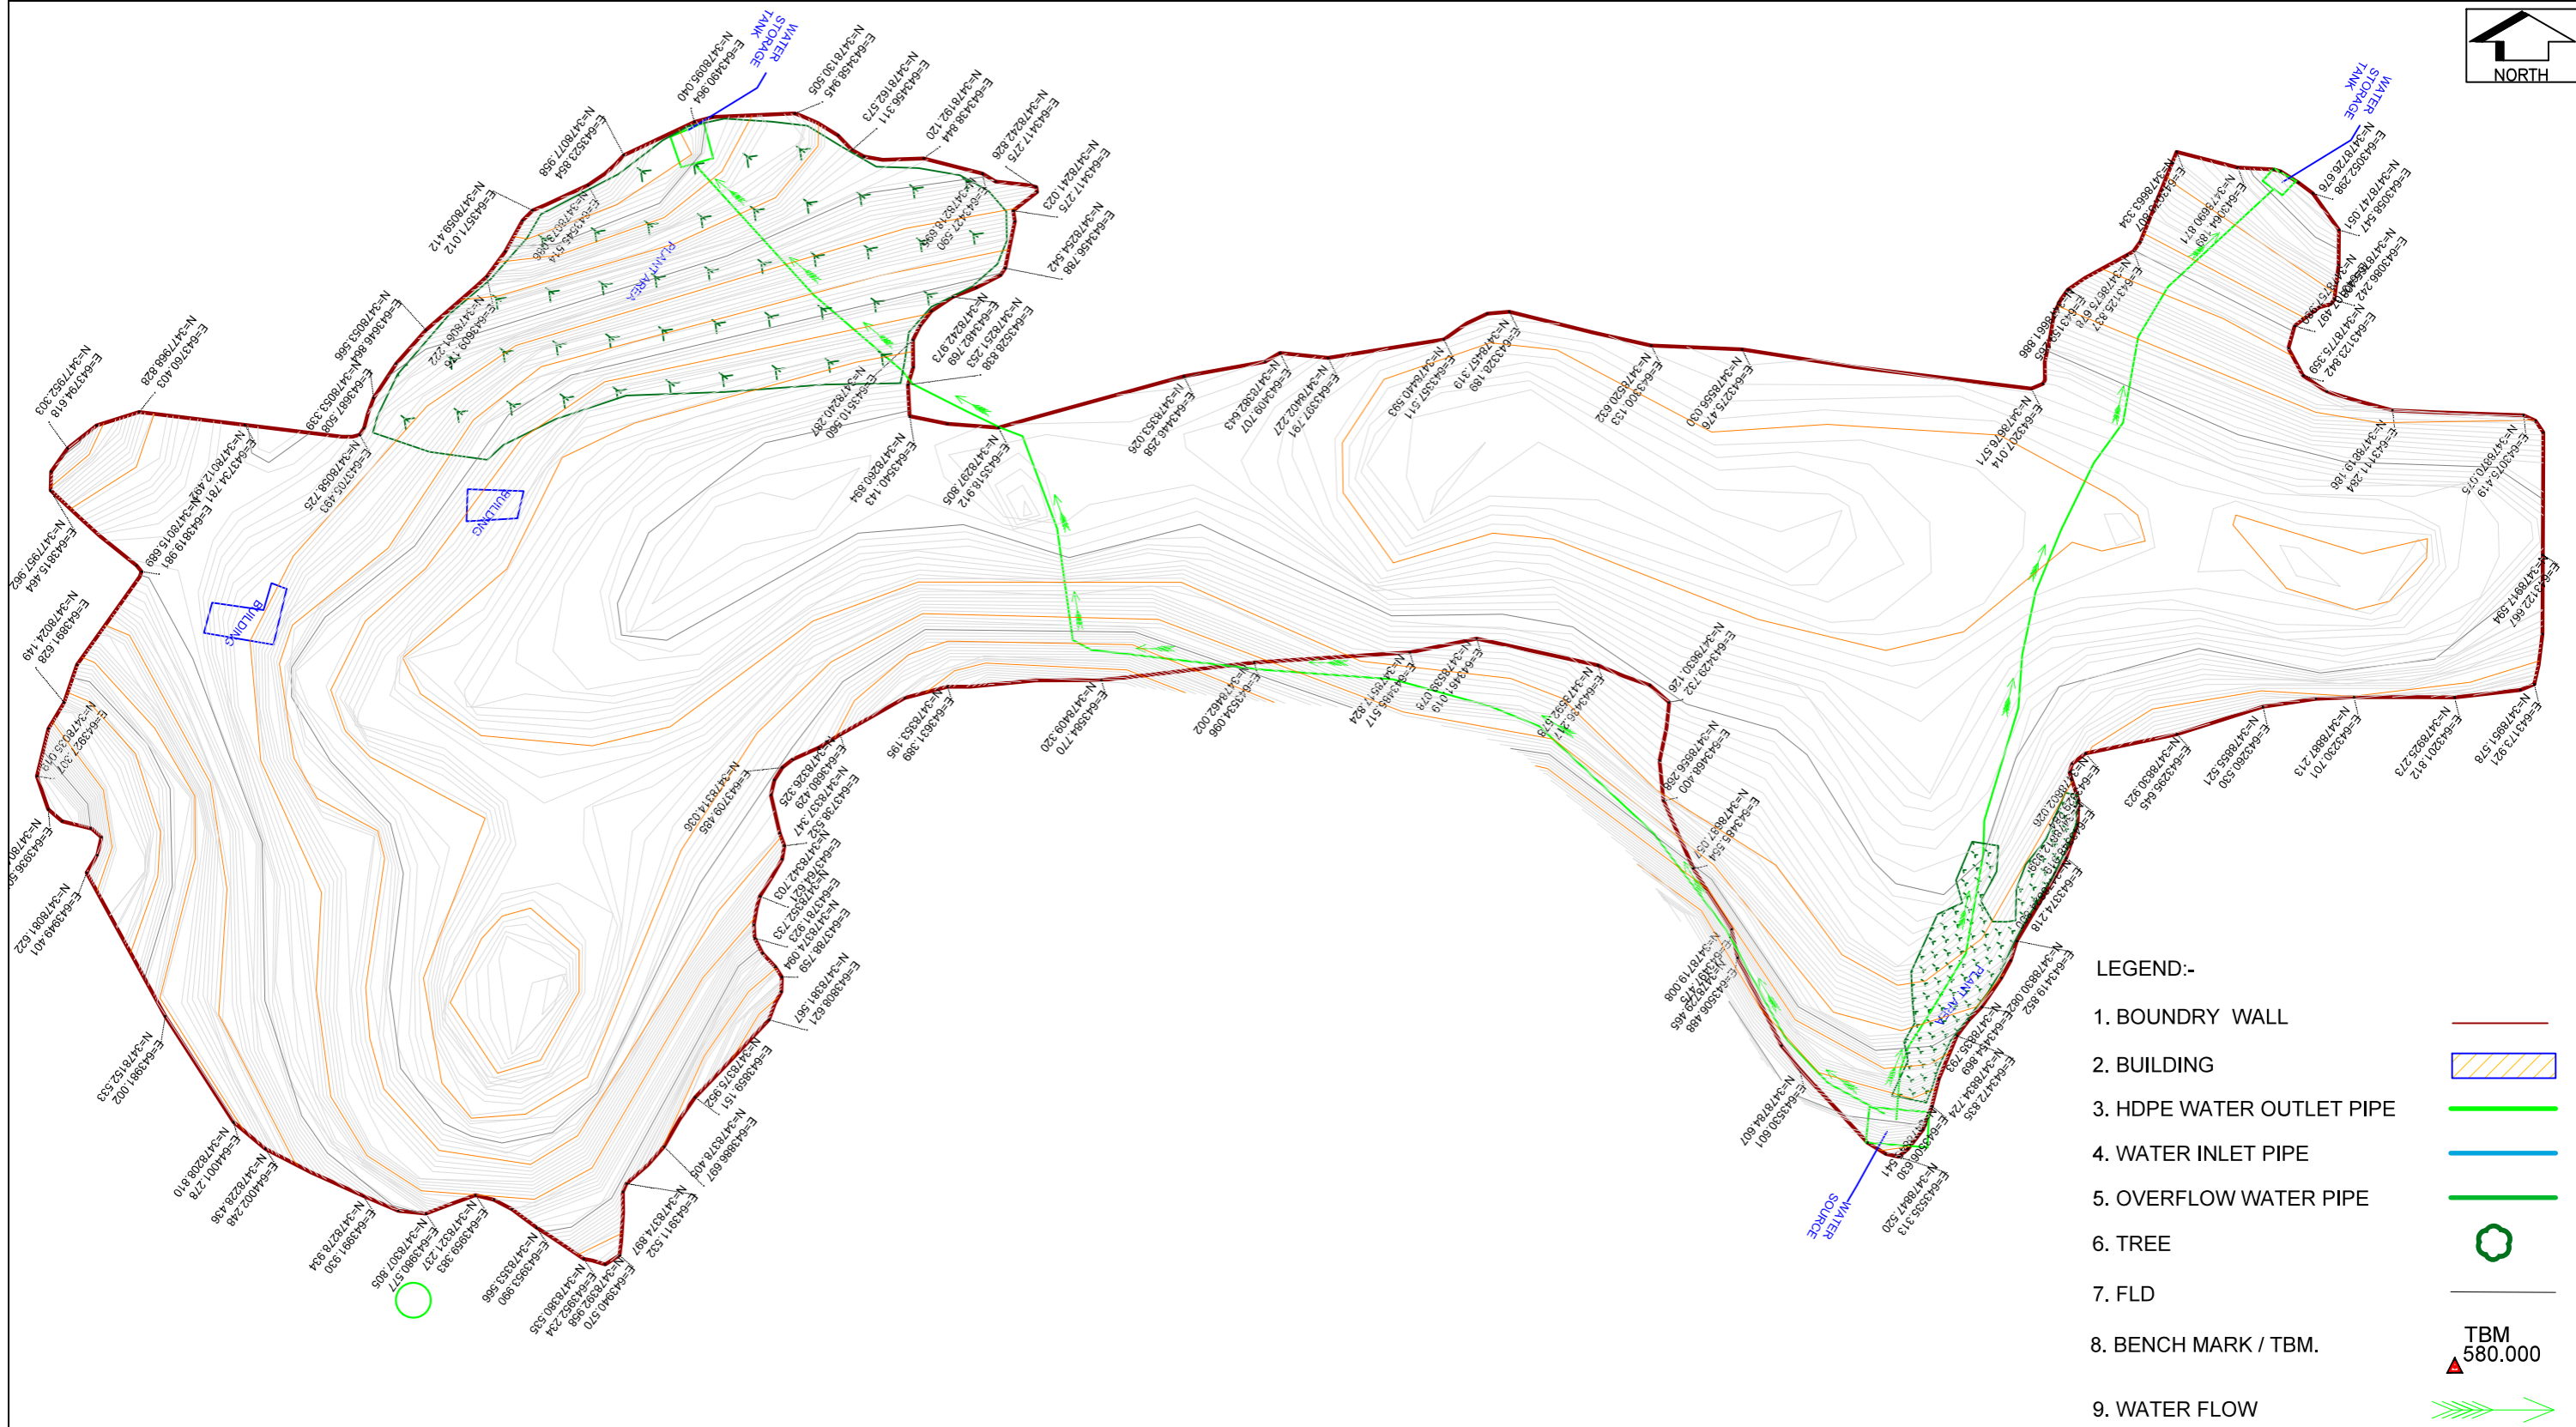

- LEGEND:-**
- 1. BOUNDRY WALL
  - 2. BUILDING
  - 3. HDPE WATER OUTLET PIPE
  - 4. WATER INLET PIPE
  - 5. OVERFLOW WATER PIPE
  - 6. TREE
  - 7. FLD
  - 8. BENCH MARK / TBM. TBM 580.000
  - 9. WATER FLOW

**DETAILED DESIGN CONSULTANCY, HP-SHIVA (PACKAGE CS09)**  
IRRIGATION, HORTICULTURE, ORCHARDS AND VALUE CHAIN DEVELOPMENT

**TOPOGRAPHICAL SURVEY FOR KOSARIYA CLUSTER**  
JHANDUTTA BLOCK, BILASPUR DISTRICT




SIGN. OF CLIENT:-			
JE	AE	EE	SE
<b>PURPOSE: FOR TENDER ONLY</b>			
<b>DO NOT SCALE</b>			
Proprietary Notice and Version Control: This document contains confidential information for use only by the 'Client' for the Project under consideration, which is provided for the sole purpose of permitting the recipient to evaluate the information submitted hereafter, in consideration of receipt of this document; unless agreed to in writing in the Contract, the recipient agrees to maintain such information in confidence and to not reproduce or otherwise disclose this information to any person outside the recipient's organization; except that there is no obligation to maintain the confidentiality of any information which was known to the recipient prior to receipt of such information from Tata Consulting Engineers Limited, or becomes publicly known through no fault of recipient, or Tata Consulting Engineers Limited, or is received without obligation of confidentiality from a third party owing no obligation of confidentiality to Tata Consulting Engineers Limited. All information given under this version over rides all and any kind of offers, assumptions, deliverables and contracts submitted verbally (and subsequently communicated in writing) or in writing or otherwise given under any and all previous version/s.			
FILE NAME 12503A-CV-30068-Rev-P0			

SCALE : NTS	DWG NO. TCE.12503A-CV-3005-LM-30068	ISSUE PO
DC & DISC: DEL-CV		

SIGN.											'P' (PRELIMINARY) ISSUES ARE NOT TO BE USED FOR CONSTRUCTION / FABRICATION BUT ARE ISSUED FOR LIMITED PURPOSES ONLY AS INDICATED IN THE SMALL BLOCK ABOVE THIS BLOCK.  CONSTRUCTION / FABRICATION WORK IS PERMITTED ON 'R' (RELEASED) ISSUES ONLY.  INFORMATION CONTAINED WITHIN 'HOLD' IS NOT RELEASED FOR CONSTRUCTION / FABRICATION, IN TIME BEFORE PROCEEDING WITH ANY CONSTRUCTION/ FABRICATION WORK RELATED TO 'HOLDS'.
INITIALS											
REVISIONS											
PO SIGN.											DATE (dd-mm-yyyy)
INITIALS	GKJ	ES	DVB					MK	DK	08-04-2022	
REVISIONS											
ISSUE	DRN	DSN	CHD	CV	EL	IC	ME		PE/PM	APPD	DATE (dd-mm-yyyy)
CLEARED											



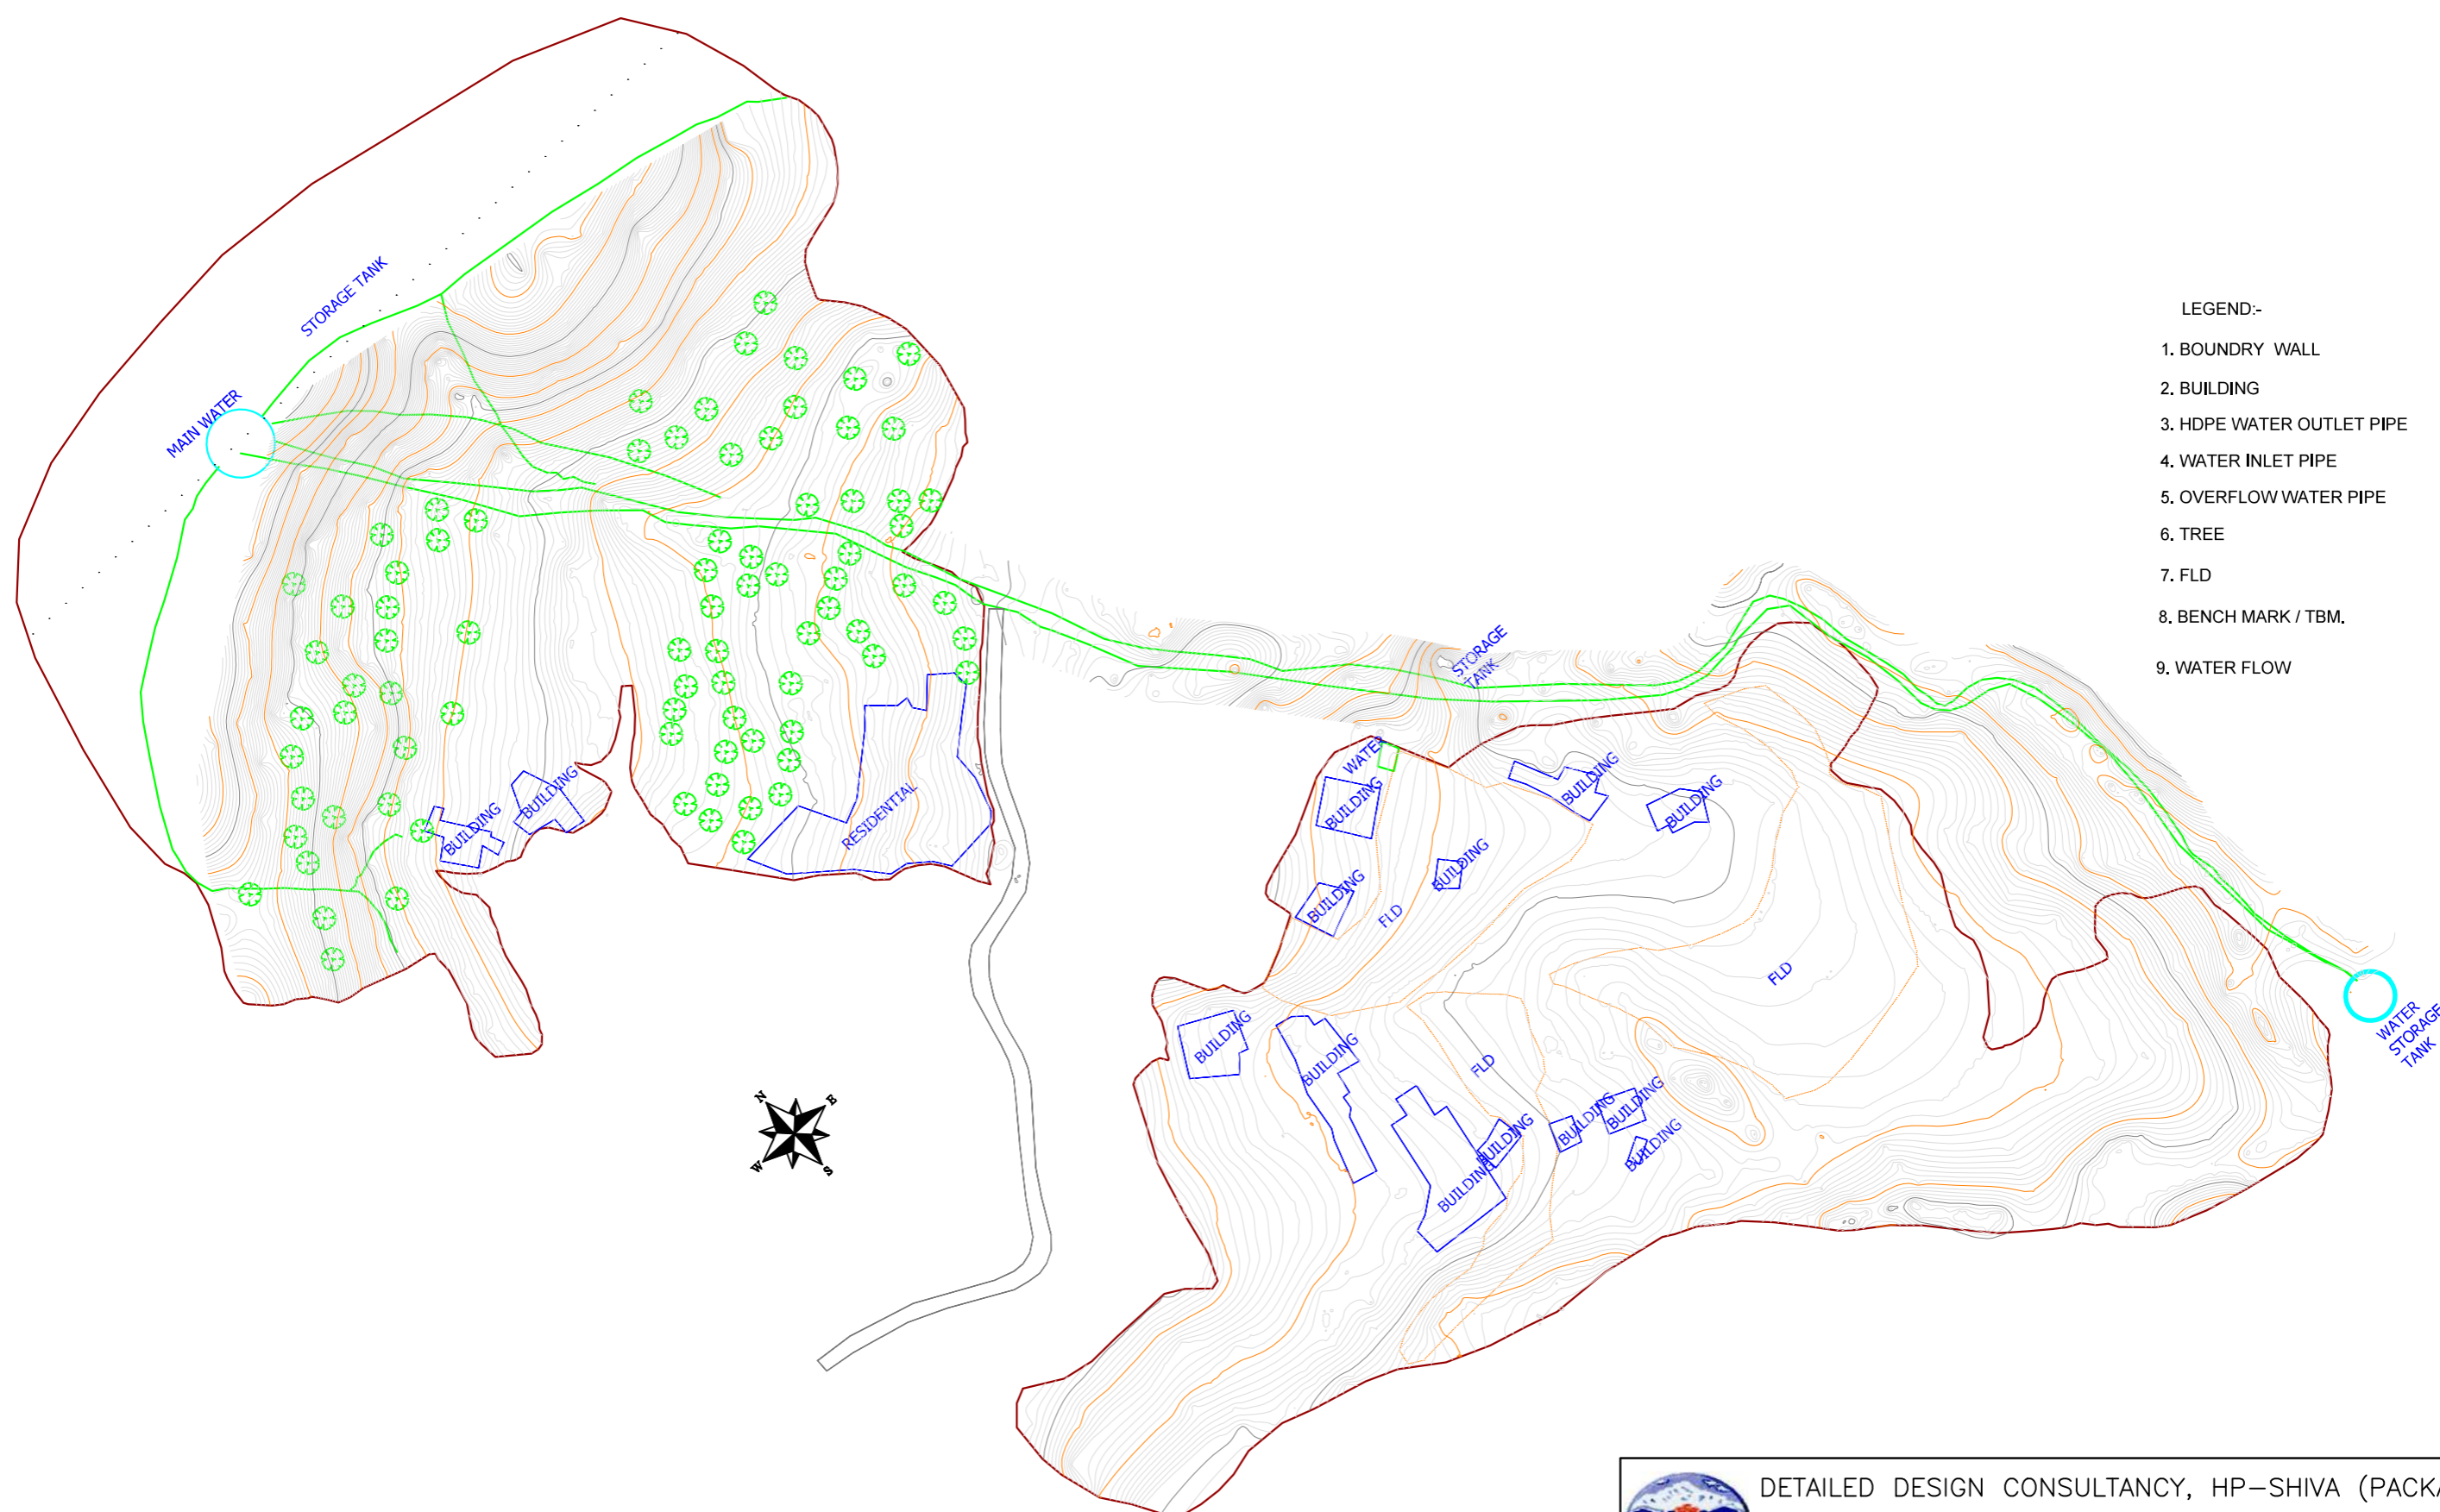

- LEGEND:-
- 1. BOUNDARY WALL —
  - 2. BUILDING
  - 3. HDPE WATER OUTLET PIPE —
  - 4. WATER INLET PIPE —
  - 5. OVERFLOW WATER PIPE —
  - 6. TREE
  - 7. FLD
  - 8. BENCH MARK / TBM.
  - 9. WATER FLOW



DETAILED DESIGN CONSULTANCY, HP-SHIVA (PACKAGE CS09)  
IRRIGATION, HORTICULTURE, ORCHARDS AND VALUE CHAIN DEVELOPMENT

TOPOGRAPHICAL SURVEY FOR TIKRI KOTLU CLUSTER  
JHANDUTTA BLOCK, BILASPUR DISTRICT

SIGN. OF CLIENT:-

JE	AE	EE	SE
----	----	----	----

PURPOSE: FOR TENDER ONLY

DO NOT SCALE

Proprietary Notice and / or Confidentiality: This document contains confidential information for use only by the Client for the Project under consideration, which is provided for the sole purpose of permitting the recipient to evaluate the information submitted hereunder. In consideration of receipt of this document, unless agreed to in contrary in the Contract, the recipient agrees to maintain such information in confidence and to not reproduce or otherwise disclose this information to any person outside the recipient's organization; except that there is no obligation to maintain the confidentiality of any information which was known to the recipient prior to receipt of such information from Tata Consulting Engineers Limited, or becomes publicly known through no fault of recipient, or Tata Consulting Engineers Limited, or is received without obligation of confidentiality from a third party owing no obligation of confidentiality to Tata Consulting Engineers Limited. All information given under this version over rides all and any kind of offers, assumptions, deliverables and contracts submitted verbally (and subsequently communicated in writing) or in writing or otherwise given under any and all previous version/s.

**TATA CONSULTING ENGINEERS LIMITED**

MUMBAI

SIGN.													
	INITIALS												
	REVISIONS												
PO	SIGN.												
	INITIALS	GKJ	ES	DVB						MK	DK	08-04-2022	
	REVISIONS												
ISSUE	DRN	DSN	CHD	CV	EL	IC	ME				PE/PM	APPD	DATE
	CLEARED												(dd-mm-yyyy)

'P' (PRELIMINARY) ISSUES ARE NOT TO BE USED FOR CONSTRUCTION / FABRICATION BUT ARE ISSUED FOR LIMITED PURPOSES ONLY AS INDICATED IN THE SMALL BLOCK ABOVE THIS BLOCK.

CONSTRUCTION / FABRICATION WORK IS PERMITTED ON 'R' (RELEASED) ISSUES ONLY.

INFORMATION CONTAINED WITHIN 'HOLD' IS NOT RELEASED FOR CONSTRUCTION / FABRICATION. FIELD MUST GET DESIGN OFFICE TO CLEAR 'HOLDS' IN TIME BEFORE PROCEEDING WITH ANY CONSTRUCTION/ FABRICATION WORK RELATED TO 'HOLDS'.


FILE NAME 12503A-CV-30069-Rev-P0

SCALE : NTS	DWG NO. TCE.12503A-CV-3005-LM-30069	ISSUE PO
DC & DISC: DEL-CV		







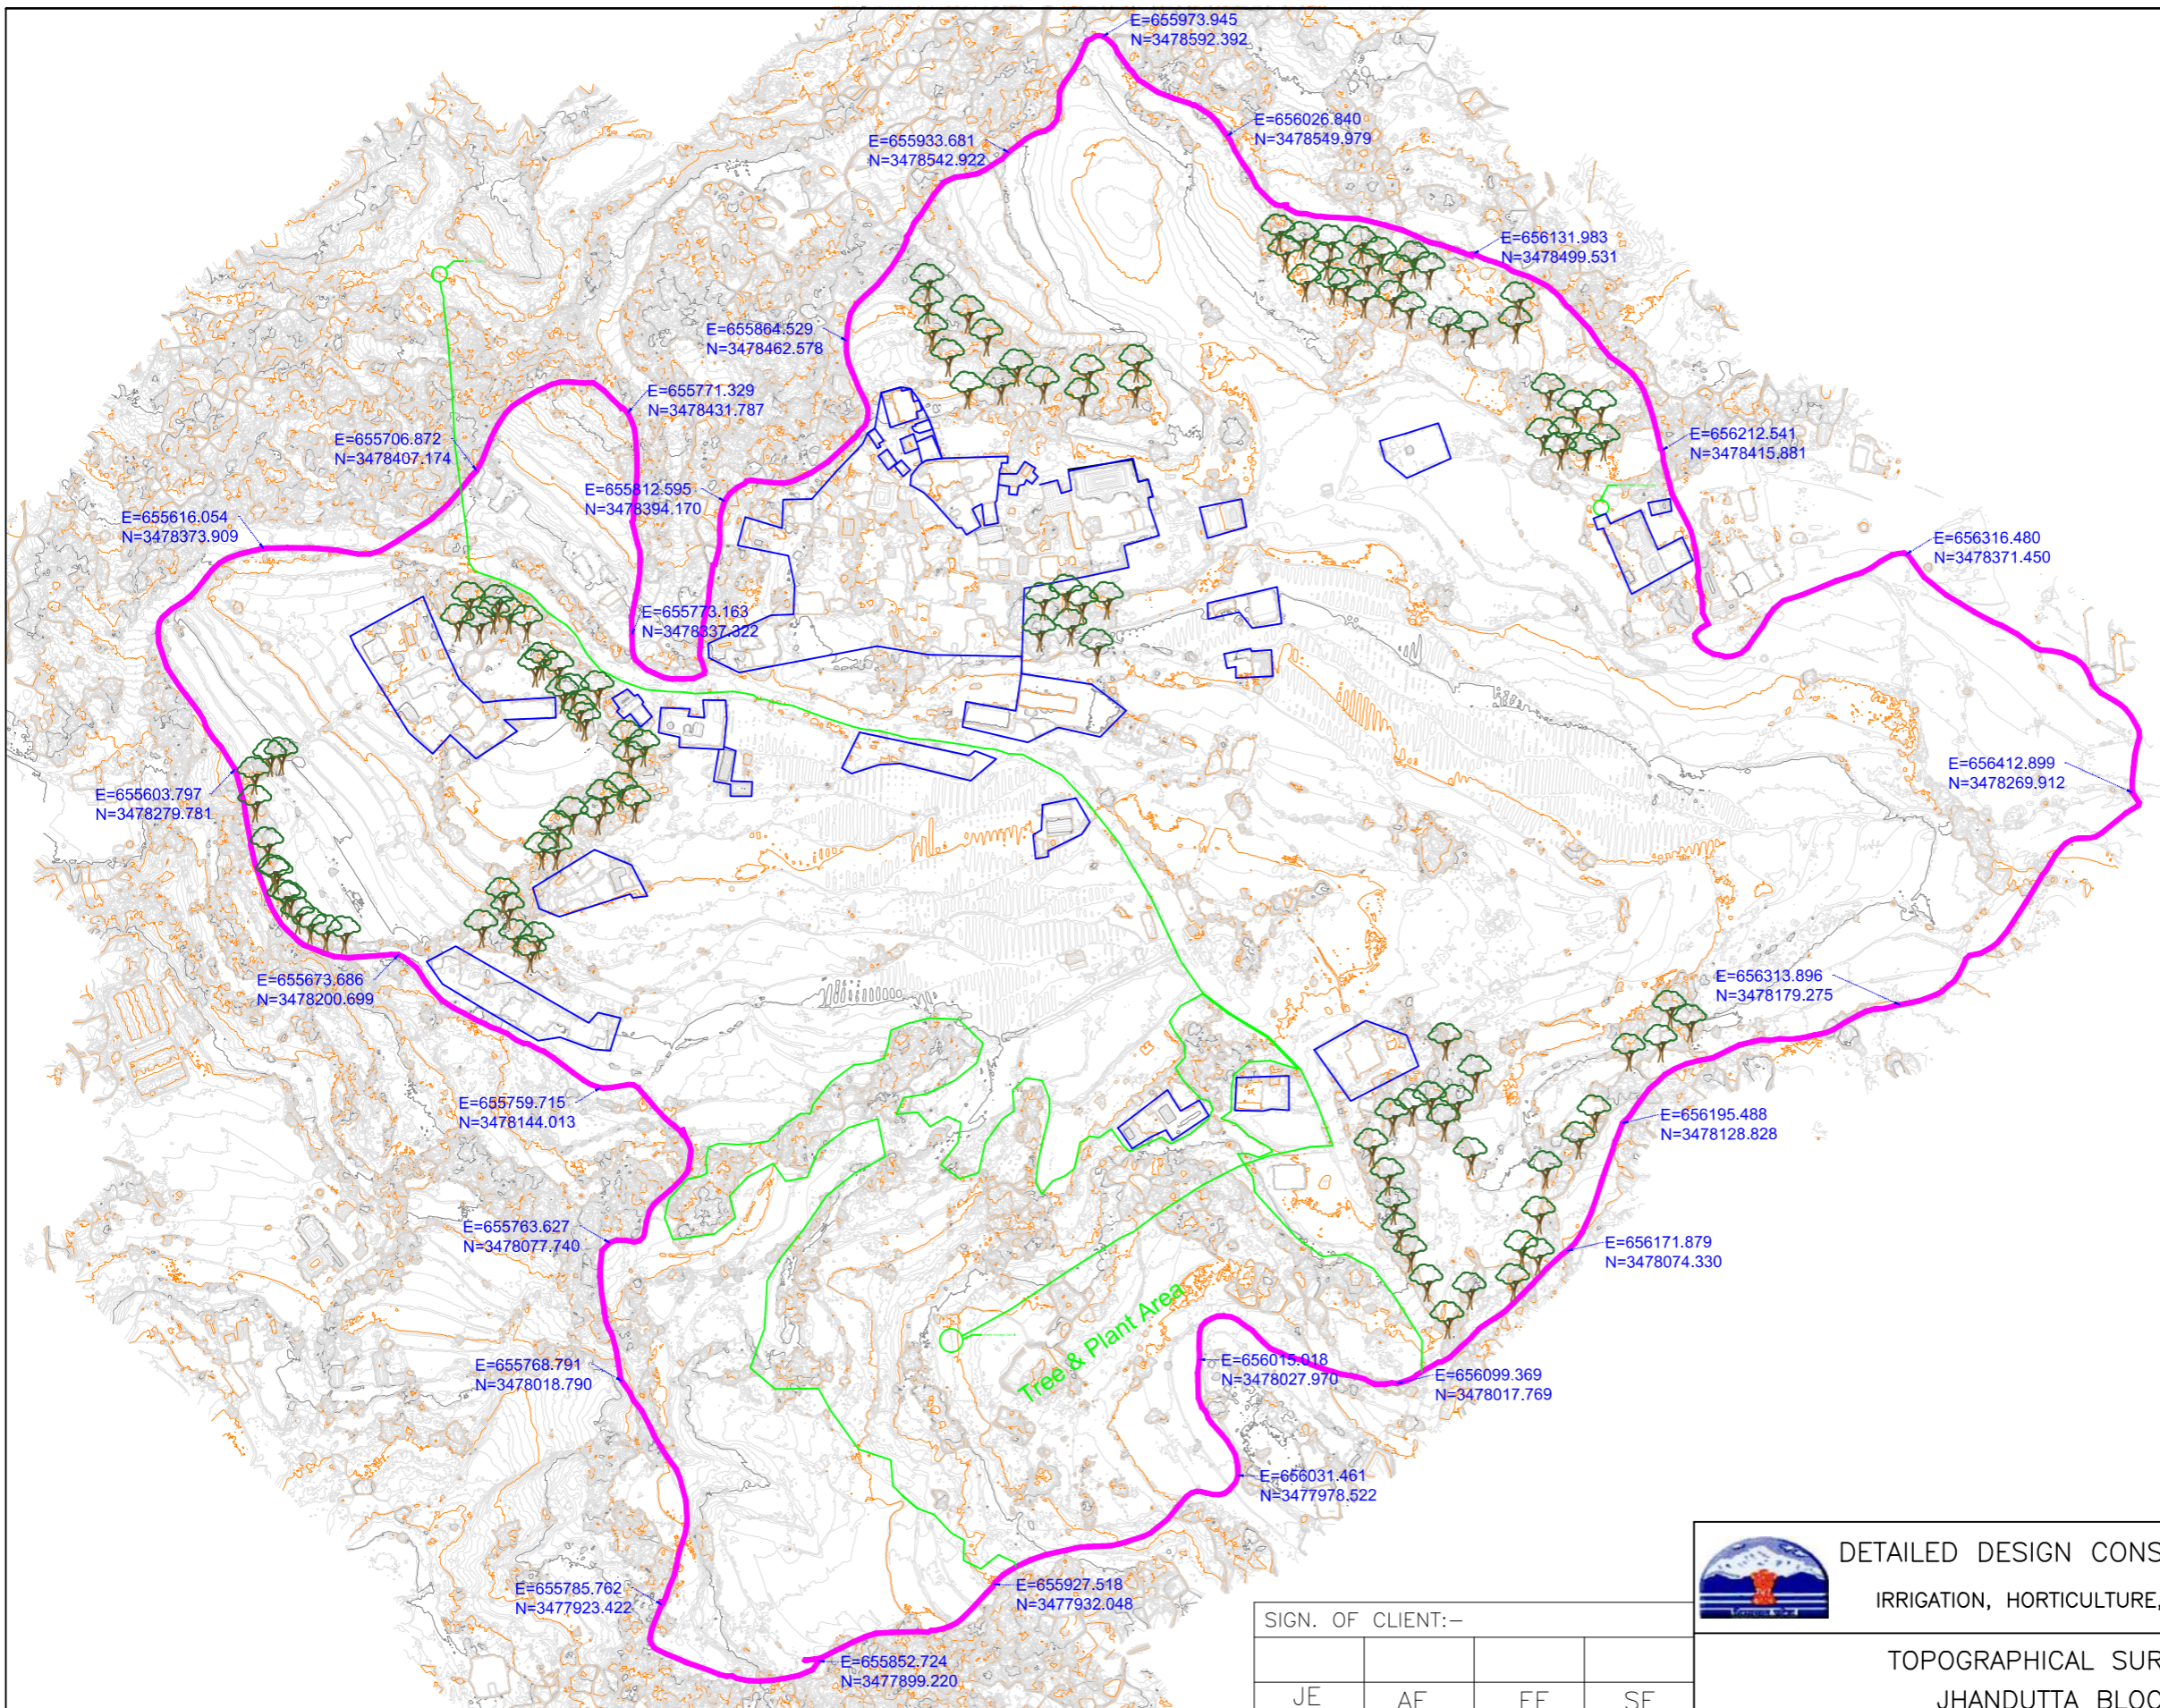

**LEGEND:-**

1. BOUNDRY WALL	
2. BUILDING	
3. HDPE WATER OUTLET PIPE	
4. WATER INLET PIPE	
5. OVERFLOW WATER PIPE	
6. TREE	
7. FLD	
8. BENCH MARK / TBM.	
9. WATER FLOW	

TBM  
580.000

SIGN.											
	INITIALS										
	REVISIONS										
PO	SIGN.										
	INITIALS	GKJ	ES	DVB					MK	DK	08-04-2022
	REVISIONS										
ISSUE	DRN	DSN	CHD	CV	EL	IC	ME		PE/PM	APPD	DATE (dd-mm-yyyy)
	CLEARED										

'P' (PRELIMINARY) ISSUES ARE NOT TO BE USED FOR CONSTRUCTION / FABRICATION BUT ARE ISSUED FOR LIMITED PURPOSES ONLY AS INDICATED IN THE SMALL BLOCK ABOVE THIS BLOCK.

CONSTRUCTION / FABRICATION WORK IS PERMITTED ON 'R' (RELEASED) ISSUES ONLY.

INFORMATION CONTAINED WITHIN 'HOLD' IS NOT RELEASED FOR CONSTRUCTION / FABRICATION. FIELD MUST GET DESIGN OFFICE TO CLEAR 'HOLDS' IN TIME BEFORE PROCEEDING WITH ANY CONSTRUCTION/ FABRICATION WORK RELATED TO 'HOLDS'.

SIGN. OF CLIENT:-


JE	AE	EE	SE
----	----	----	----

PURPOSE: FOR TENDER ONLY


DO NOT SCALE

Proprietary Notice and Vendor Control: This document contains confidential information for use only by the Client. It is provided for the sole purpose of permitting the recipient to evaluate the information submitted hereon. In consideration of receipt of this document, unless agreed to in contrary in the Contract, the recipient agrees to maintain such information in confidence and to not reproduce or otherwise disclose this information to any person outside the recipient's organization, except that there is no obligation to maintain the confidentiality of any information that was known to the recipient prior to receipt of such information from Tata Consulting Engineers Limited, or becomes publicly known through no fault of recipient, or Tata Consulting Engineers Limited, or is received without obligation of confidentiality from a third party owing no obligation of confidentiality to Tata Consulting Engineers Limited. All information given under this version over rides all and any kind of offers, assumptions, deliverables and contracts submitted verbally (and subsequently communicated in writing) or in writing or otherwise given under any and all previous version/s.

FILE NAME 12503A-CV-30071-Rev-P0


**DETAILED DESIGN CONSULTANCY, HP-SHIVA (PACKAGE CS09)**  
 IRRIGATION, HORTICULTURE, ORCHARDS AND VALUE CHAIN DEVELOPMENT

**TOPOGRAPHICAL SURVEY FOR TIHRI CLUSTER**  
**JHANDUTTA BLOCK, BILASPUR DISTRICT**


**TATA CONSULTING ENGINEERS LIMITED**  
 MUMBAI

SCALE : NTS	DWG NO. TCE.12503A-CV-3005-LM-30071	ISSUE PO
DC & DISC: DEL-CV		


















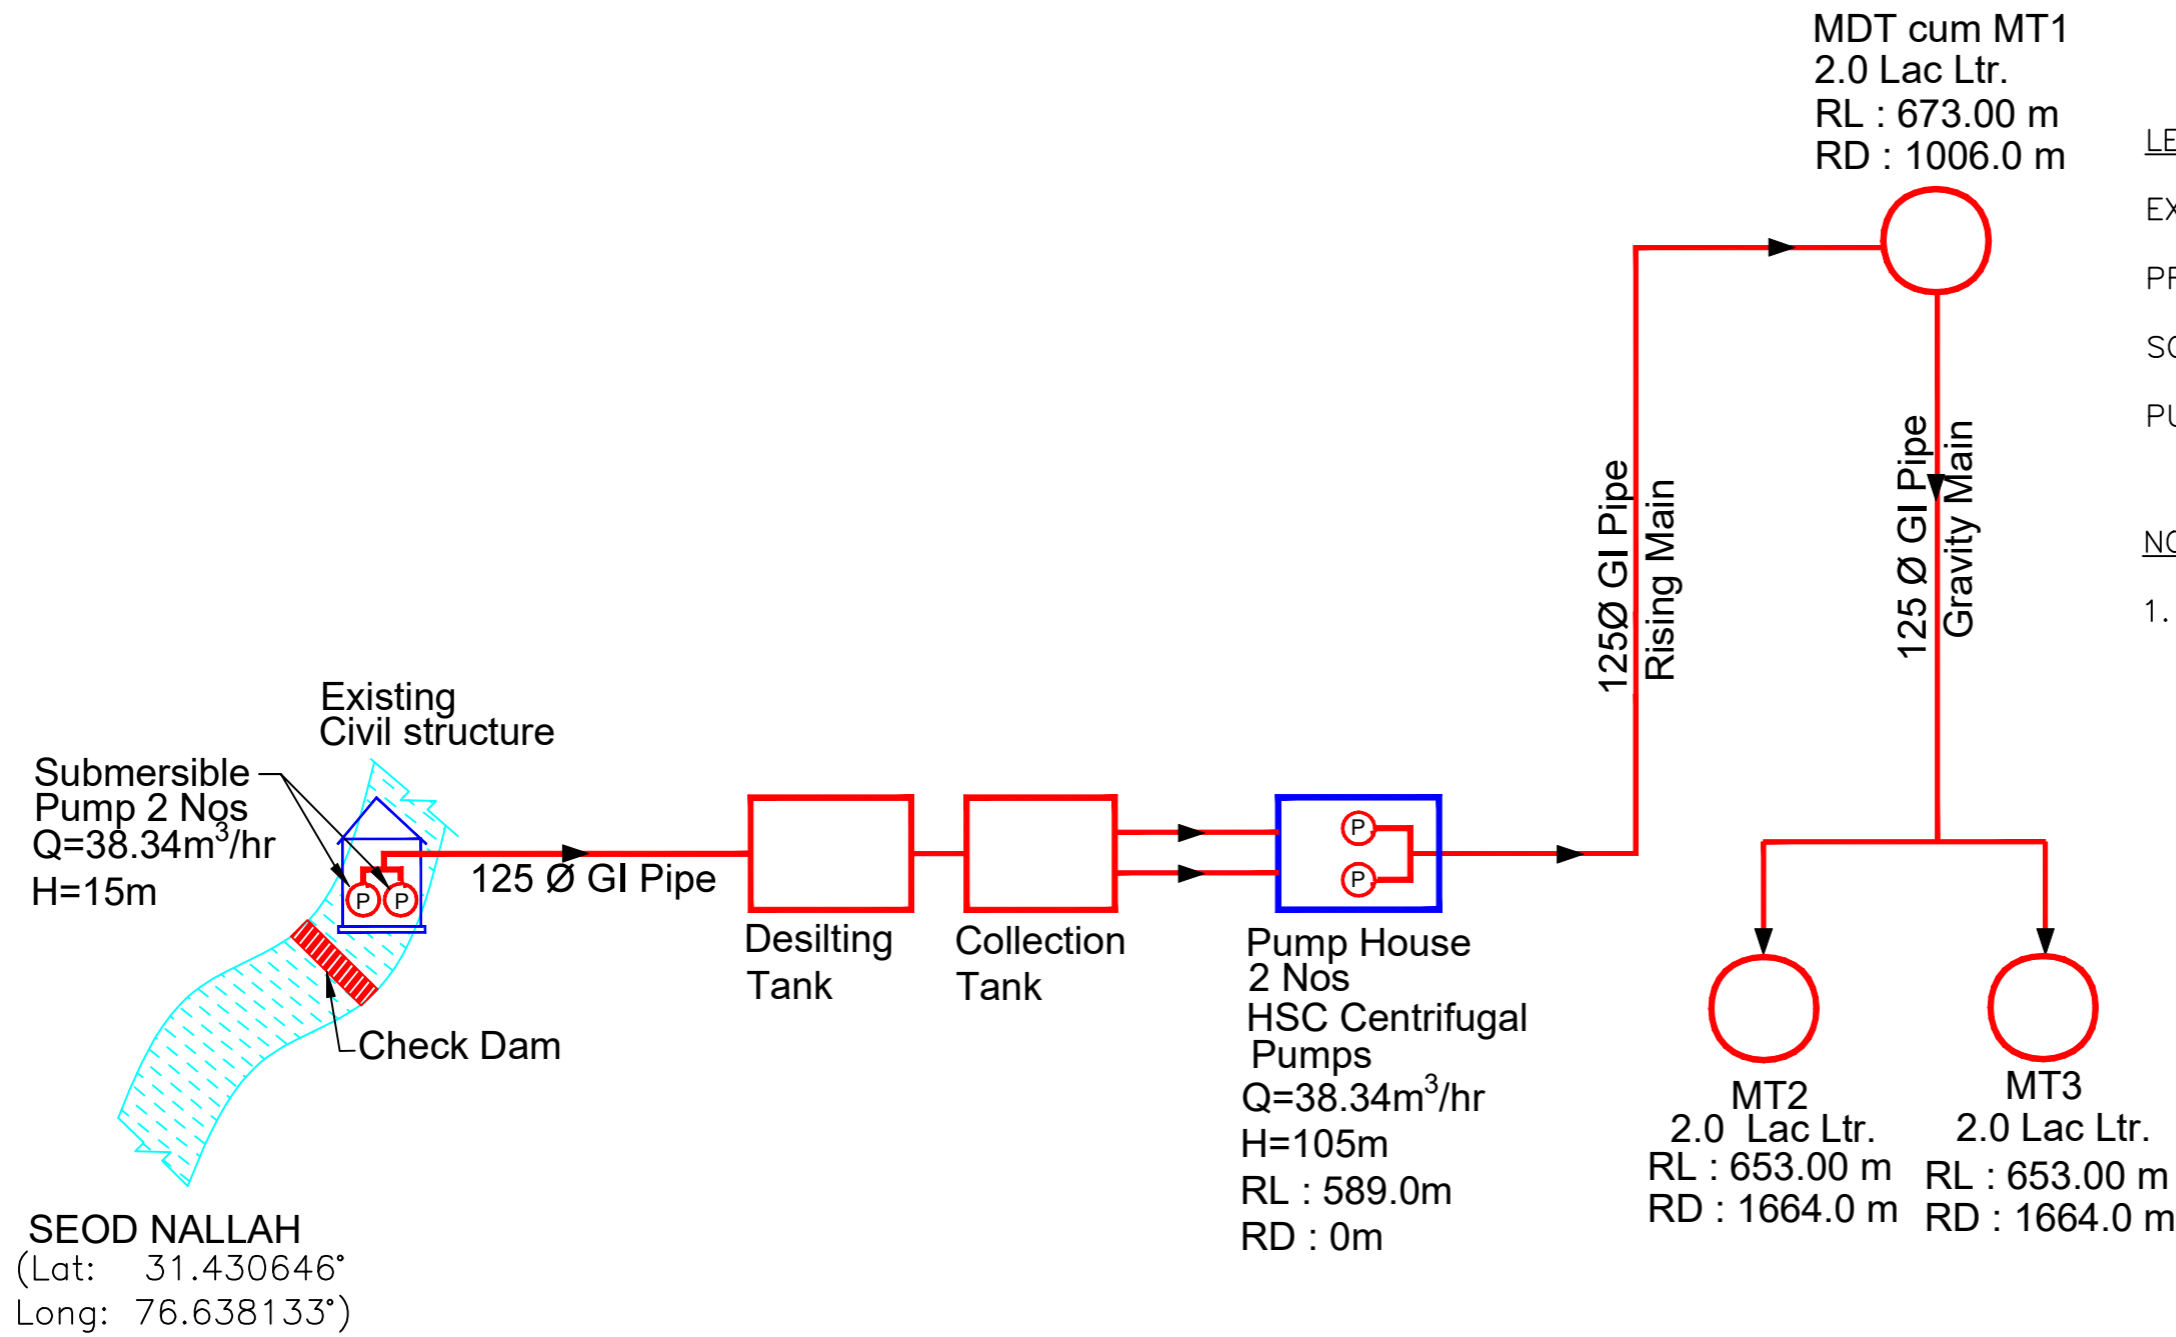

FLOW DIAGRAM OF PROPOSED LIS TIHRI (NON FUNCTIONAL SCHEME-29.15 Ha)

SIGN. OF CLIENT:-											
DETAILED DESIGN CONSULTANCY, HP-SHIVA (PACKAGE CS09) IRRIGATION, HORTICULTURE, ORCHARDS AND VALUE CHAIN DEVELOPMENT											
FLOW DIAGRAM FOR PROPOSED LIS TIHRI JHANDUTTA BLOCK BILASPUR DISTRICT											
<b>TATA CONSULTING ENGINEERS LIMITED</b> MUMBAI											
SCALE : NTS						DWG NO. TCE.12503A-CV-3082-FD-30082			ISSUE P1		
FILE NAME 12503A-CV-30082-Rev-P1						DC & DISC: DEL-CV					

P1	SIGN.	SM	ES	DVP						MK	DK	27-05-2022
	REVISIONS AS PER CLIENT OBSERVATION											
P0	SIGN.	SM	ES	DVP						MK	DK	25-04-2022
	REVISIONS											
ISSUE	DRN	DSN	CHD	CV	EL	IC	ME		PE/PM	APPD	DATE	(dd-mm-yyyy)
INFORMATION CONTAINED WITHIN 'HOLD' IS NOT RELEASED FOR CONSTRUCTION / FABRICATION WORK RELATED TO 'HOLDS'. FIELD MUST GET DESIGN OFFICE TO CLEAR 'HOLDS' IN TIME BEFORE PROCEEDING WITH ANY CONSTRUCTION/ FABRICATION WORK RELATED TO 'HOLDS'.												

'P' (PRELIMINARY) ISSUES ARE NOT TO BE USED FOR CONSTRUCTION / FABRICATION BUT ARE ISSUED FOR LIMITED PURPOSES ONLY AS INDICATED IN THE SMALL BLOCK ABOVE THIS BLOCK.

CONSTRUCTION / FABRICATION WORK IS PERMITTED ON 'R' (RELEASED) ISSUES ONLY.

INFORMATION CONTAINED WITHIN 'HOLD' IS NOT RELEASED FOR CONSTRUCTION / FABRICATION. FIELD MUST GET DESIGN OFFICE TO CLEAR 'HOLDS' IN TIME BEFORE PROCEEDING WITH ANY CONSTRUCTION/ FABRICATION WORK RELATED TO 'HOLDS'.


Proprietary Notice and Version Control This document contains confidential information for use only by the Client; for the Project under consideration, which is provided for the sole purpose of permitting the recipient to evaluate the information submitted herewith. In consideration of receipt of this document, unless agreed to in contrary in the Contract, the recipient agrees to maintain such information in confidence and to not reproduce or otherwise disclose this information to any person outside the recipient's organization, except that there is no obligation to maintain the confidentiality of any information which was known to the recipient prior to receipt of such information from Tata Consulting Engineers Limited, or becomes publicly known through no fault of recipient, or Tata Consulting Engineers Limited, or is received without obligation of confidentiality from a third party using no obligation of confidentiality to Tata Consulting Engineers Limited. All information given under this version over rides all and any kind of offers, assumptions, deliberations and contracts submitted verbally (and subsequently communicated in writing) or in writing or otherwise given under any and all previous versions/s.









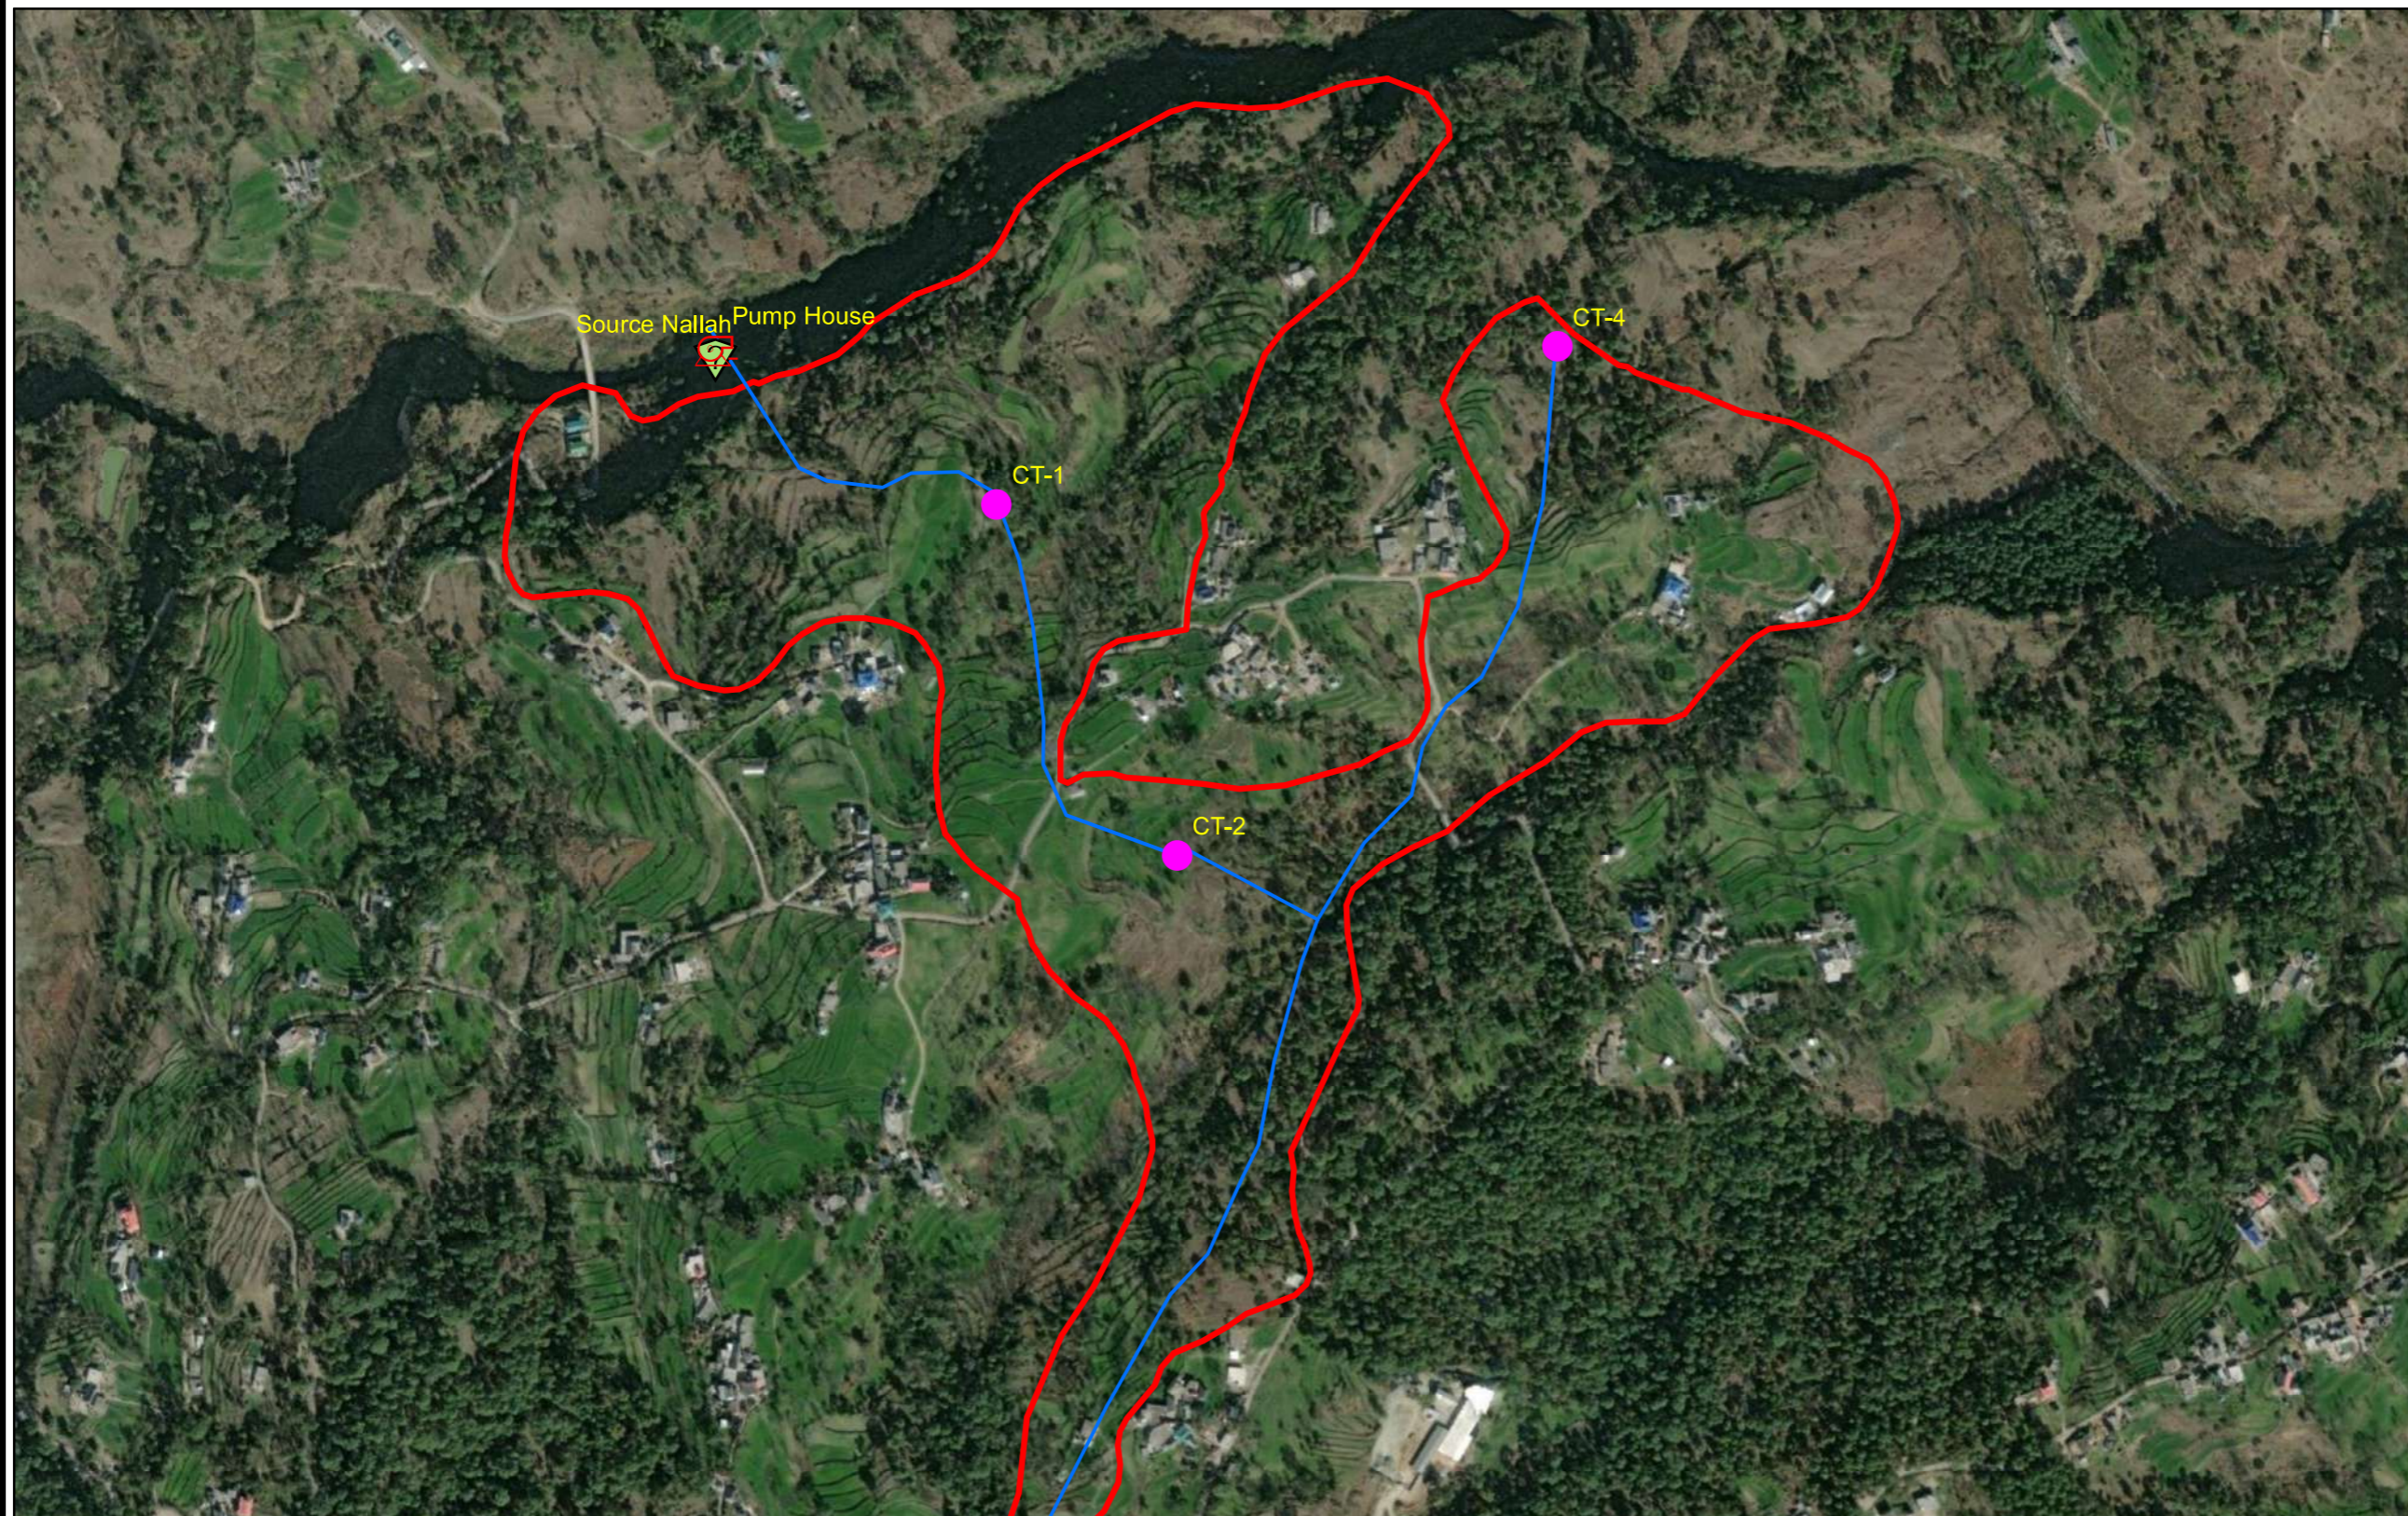






### Legend

-  Source
-  Pump House
-  CT
-  Rising\_Main
-  BalhSihna



SIGN. OF CLIENT:-			
JE	AE	EE	SE



**DETAILED DESIGN CONSULTANCY, HP-SHIVA  
(PACKAGE CS09)**

IRRIGATION, HORTICULTURE, ORCHARDS AND VALUE CHAIN DEVELOPMENT

SIGN.											
	INITIALS										
REVISIONS											
P0	SIGN.										
	INITIALS	GKJ	ES	MK		MK	DK	27-04-2022			
REVISIONS											
ISSUE	DRN	DSN	CHD	CV	EL	IC	ME		PE/PM	APPD.	DATE
				CLEARED							

'P' (PRELIMINARY) ISSUES ARE NOT TO BE USED FOR CONSTRUCTION / FABRICATION BUT ARE ISSUED FOR LIMITED PURPOSES ONLY AS INDICATED IN THE SMALL BLOCK ABOVE THIS BLOCK.


CONSTRUCTION / FABRICATION WORK IS PERMITTED ON 'R' (RELEASED) ISSUES ONLY.

INFORMATION CONTAINED WITHIN 'HOLD' IS NOT RELEASED FOR CONSTRUCTION / FABRICATION. FIELD MUST GET DESIGN OFFICE TO CLEAR 'HOLDS' IN TIME BEFORE PROCEEDING WITH ANY CONSTRUCTION/FABRICATION WORK RELATED TO 'HOLDS'.

**PURPOSE : FOR TENDER ONLY**

Proprietary Notice and Version Control This document contains confidential information for use only by the "Client"; for the Project under consideration, which is provided for the sole purpose of permitting the recipient to evaluate the information submitted here with. In consideration of receipt of this document, unless agreed to in contrary in the Contract, the recipient agrees to maintain such information in confidence and to not reproduce or otherwise disclose this information to any person outside the recipient's organisation; except that there is no obligation to maintain the confidentiality of any information which was known to the recipient prior to receipt of such information from Tata Consulting Engineers Limited, or becomes publicly known through no fault of recipient, or Tata Consulting Engineers Limited, or is received without obligation of confidentiality from a third party owing no obligation of confidentiality to Tata Consulting Engineers Limited. All information given under this version over rides all and any kind of offers, assumptions, deliverables and contracts submitted verbally (and subsequently communicated in writing) or in writing or otherwise given under any and all previous version/s.


File Name:12503A-CV-30661-Rev-P0









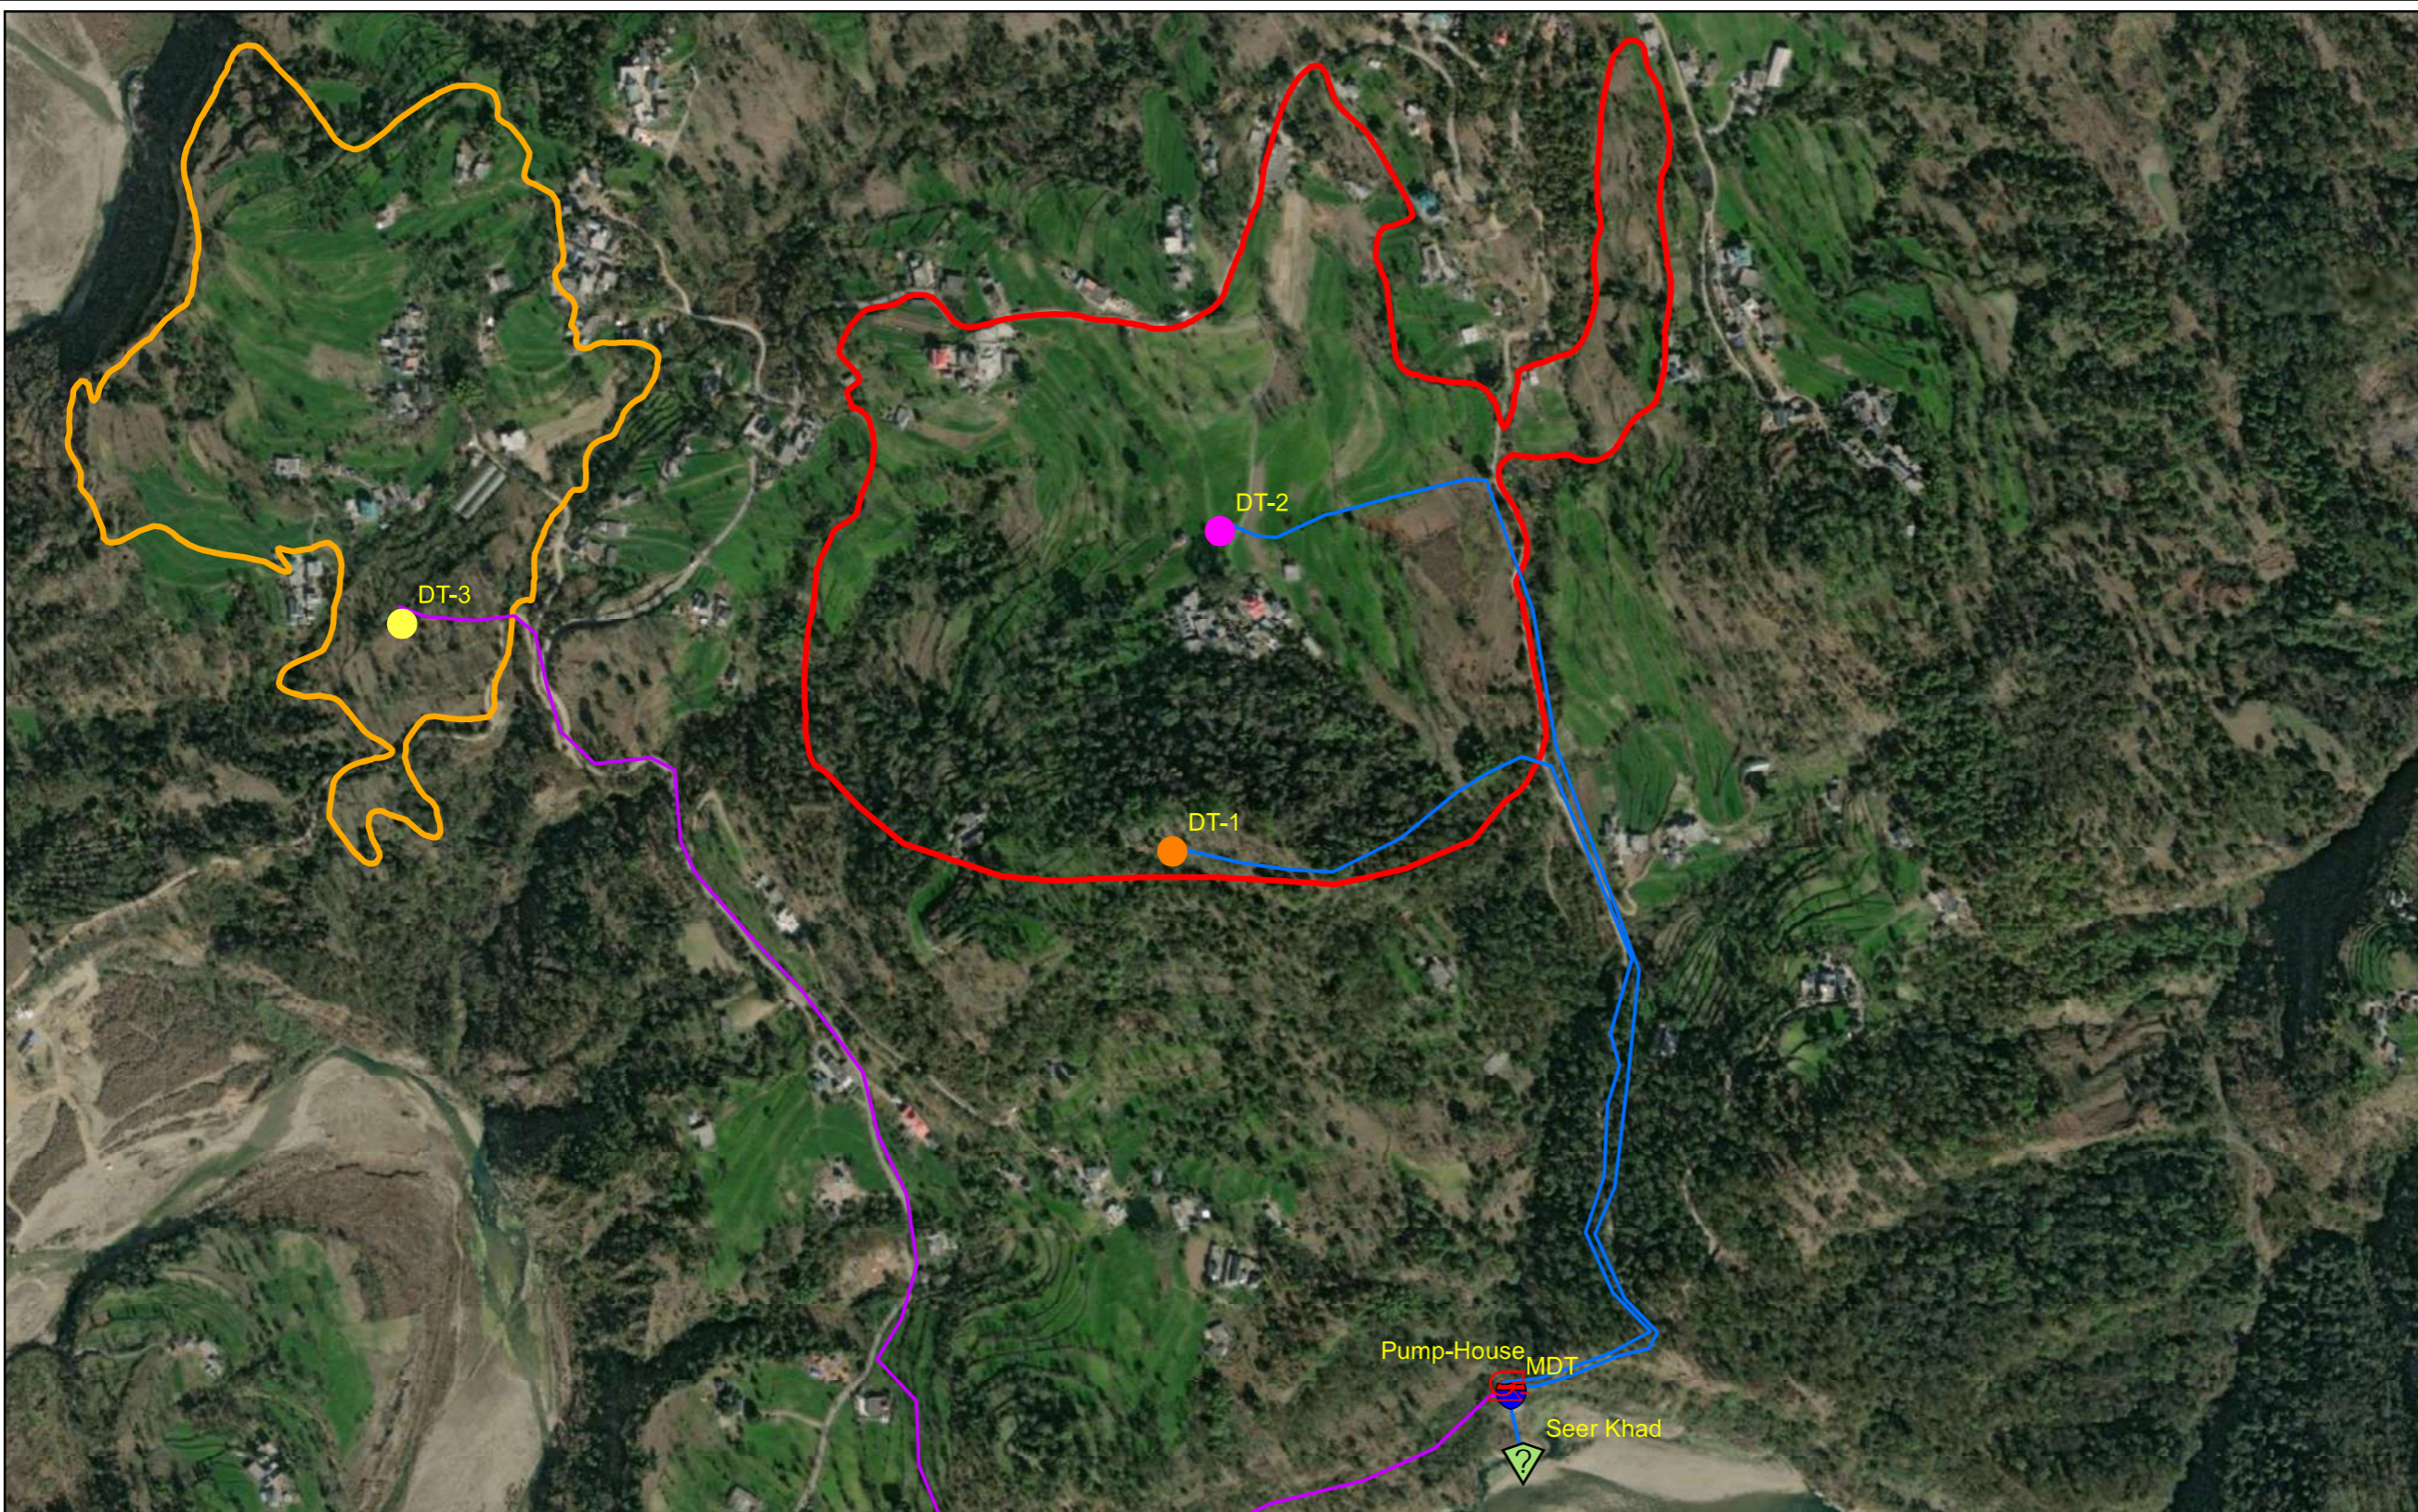



**TATACONSULTING ENGINEERS LIMITED.  
MUMBAI**

SCALE:- 1:6,000	DWG. No:-	ISSUE:-
DL.CEN.:- DEL-CV	TCE.12503A-CV-3005-LM-30661	P0





**Legend**

-  Source of Seer Khad
-  Pump-House
-  DT-1
-  DT-2
-  MDT
-  Location\_of\_Fagog\_Banjholi
-  Rising\_Main\_of\_Fagog\_Banjholi
-  Rising\_Main\_of\_Fagog
-  Fagog
-  Fafog\_Banjholi

SIGN. OF CLIENT:-

JE	AE	EE	SE
----	----	----	----



**DETAILED DESIGN CONSULTANCY, HP-SHIVA  
(PACKAGE CS09)**

IRRIGATION, HORTICULTURE, ORCHARDS AND VALUE CHAIN DEVELOPMENT

SIGN.											
	INITIALS										
REVISIONS											
P0	SIGN.										
	INITIALS	GKJ	ES	MK		MK	DK	27-04-2022			
REVISIONS											
ISSUE	DRN	DSN	CHD	CV	EL	IC	ME		PE/PM	APPD.	DATE
	CLEARED										

'P' (PRELIMINARY) ISSUES ARE NOT TO BE USED FOR CONSTRUCTION / FABRICATION BUT ARE ISSUED FOR LIMITED PURPOSES ONLY AS INDICATED IN THE SMALL BLOCK ABOVE THIS BLOCK.


CONSTRUCTION / FABRICATION WORK IS PERMITTED ON 'R' (RELEASED) ISSUES ONLY.

INFORMATION CONTAINED WITHIN 'HOLD' IS NOT RELEASED FOR CONSTRUCTION / FABRICATION. FIELD MUST GET DESIGN OFFICE TO CLEAR 'HOLDS' IN TIME BEFORE PROCEEDING WITH ANY CONSTRUCTION/FABRICATION WORK RELATED TO 'HOLDS'.

**PURPOSE : FOR TENDER ONLY**

Proprietary Notice and Version Control This document contains confidential information for use only by the "Client"; for the Project under consideration, which is provided for the sole purpose of permitting the recipient to evaluate the information submitted here with in consideration of receipt of this document; unless agreed to in contrary in the Contract, the recipient agrees to maintain such information in confidence and to not reproduce or otherwise disclose this information to any person outside the recipient's organisation; except that there is no obligation to maintain the confidentiality of any information which was known to the recipient prior to receipt of such information from Tata Consulting Engineers Limited, or becomes publicly known through no fault of recipient, or Tata Consulting Engineers Limited, or is received without obligation of confidentiality from a third party owing no obligation of confidentiality to Tata Consulting Engineers Limited. All information given under this version over rides all and any kind of offers, assumptions, deliverables and contracts submitted verbally (and subsequently communicated in writing) or in writing or otherwise given under any and all previous version/s.

File Name:12503A-CV-30662-Rev-P0



**TATACONSULTING ENGINEERS LIMITED.  
MUMBAI**

SCALE:- 1:6,000	DWG. No:-	ISSUE:-
DL.CEN:- DEL-CV	TCE.12503A-CV-3005-LM-30662	P0